



LINFIELD, HUNTER & JUNIUS, INC.

PROFESSIONAL ENGINEERS,
ARCHITECTS AND SURVEYORS

3608 18th Street / Suite 200
Metairie, Louisiana 70002
(504) 833-5300 / (504) 833-5350 fax
LHJ@LHJjunius.com

Ralph W. Junius, Jr., P.E.
Nathan J. Junius, P.E., P.L.S.
Anthony F. Goodgion, P.E.
Charles E. Mouton, AIA
Robert E. Nockton, P.E.
Mark K. Annino
Casey M. Genovese, P.E.

Daniel A. Flores, P.E.
John M. Jackson, P.E.
Vincent J. Leco, III, P.E.
Eric R. Wright, P.E.
Timothy J. Roth, P.E.
Richard A. Van Wootten, P.E.

November 6, 2025

Ms. Haley Webb, Senior Planner
New Orleans City Planning Commission
Office of Business and External Services
1300 Perdido Street, 7th Floor
New Orleans, LA 70112

**Re: 3800 Texas Drive
New Orleans, LA
Project Number: DR058-25
Our File #: 23-104**

Dear Ms. Webb:

CPC Design Advisory Committee Provisos [10.15.2025] - Response for DR058-25 (3800 Texas Drive)

1. Orient the building to front along Texas Drive.

R:/ Orienting the building to front along Texas Drive would create a through lot scenario with two front yards. No parking is permitted in the front or corner yard setback areas and would require a variance from the BZA to allow the parking per 22.8.A.1. Please see below.

22.8.A.1 Residential Uses

a. All required off-street vehicle parking spaces for residential uses and the residential component of mixed-use developments shall be located on the same lot as the building or use served, unless otherwise authorized by this Ordinance.

b. For all residential dwellings, required vehicle parking spaces are permitted in private driveways or parking pads, but are prohibited in the following areas (a driveway leading to a required off-street parking space may be located in a required yard area):

i. on non-vehicular public rights-of-way.

ii. between the front facade of any building and the nearest point of the front yard property line, unless in accordance with Section 22.11.B.1.a.i.

iii. between the facade of any building and the nearest point of the corner side yard property line.

2. Address the monotonous roof line with dormers or gables.

R:/ The roof line has incorporated hip-end roof geometry, which has been revised to address the monotonous roof line – please see revised A201 – Building Elevation, A202 Building Elevations, and A121 – Roof Plan.

- 3A. Make the condenser units less visually obtrusive from within the site. And locate the condenser units so as to not block window openings on the ground floor.

R:/ The location of the condenser units has been revised to be less visually obtrusive from within the site. The landscape plan (LS-1) illustrates the condenser units being screened by Dwarf Burford Holly (42), White Indian Hawthorn (7), and Eagleston Holly (1). The condenser units have been strategically placed to maintain the required mechanical clearances, and provide a clear sight line from the first floor window, bedrooms and as to not block window openings on the ground floor – please see revised layout on A101 – First Floor Plan and LS-1 Landscape

- 3B. Provide landscaping in accordance with Article 23 landscaping requirements.

R:/ The landscaping is designed in accordance with Article 23 requirements, – please see revised SP-1 and sheets LS-1 and LS-2

4. Modify the site plan to connect the multi-family development with nearby transit stops. This could be through street trees to improve walkability and the provision of a 20-foot long accessible pathway from the transit locations to the building entry.

R:/ The sidewalks at the transit stop leading to the front and side entry gates will be resurfaced and graded to create an accessible path. The goal is to improve walkability and enhance the pedestrian experience – please see sheet SP-1 illustrating an accessible path. The project additionally provides trees along Memorial Park Drive within the property line and additional perimeter landscaping along Texas Dr.

5. Provide visual interest and break down the massing of the front building façade through changes in plane, such as one-foot setbacks for portions, or include material changes to break up the façade.

R:/ The massing of the front building façade has been revised with one-foot setbacks and material changes throughout to provide visual interest and break up the façade – please see revised A101 – First Floor Plan and A201 – Building Elevations.

 
6. Re-design fence to appear welcoming to tenant and from the public perspective.

Ms. Haley Webb, Senior Planner
New Orleans City Planning Commission
Office of Business and External Services
Page 3
November 6, 2025

R:/ The fence will be similar in nature to the ones surrounding the proposal's site – the proposed aluminum picket fence will provide visibility for the pedestrian and residents as well as provide safety for the residents within the lot, and match the aesthetic of the surrounding lots – please see SP-1 and fence detail on sheet A052.

Very truly yours,

LINFIELD, HUNTER & JUNIUS, INC.



Charles E. Mouton, AIA
Director of Architecture

CEM/dlm

New Apartments Building

3800 Texas Dr, New Orleans, LA
70114

GENERAL NOTES:

- THE CONTRACTOR AND ALL SUB-CONTRACTORS ARE TO READ ALL PORTIONS AND SECTIONS OF THE CONTRACT DOCUMENTS.
- THE CONTRACTOR SHALL REVIEW FOR COMPLIANCE WITH THE CONTRACT DOCUMENTS, APPROVE AND SUBMIT TO THE ARCHITECTS SHOP DRAWINGS, PRODUCT DATA, SAMPLES AND SIMILAR SUBMITTALS REQUIRED BY THE CONTRACT DOCUMENTS PRIOR TO SENDING TO THE ARCHITECT. THE CONTRACTOR'S REVIEW STAMP CONFIRMS COMPLIANCE WITH THE CONTRACT DOCUMENTS AND INTENT. ANY DEVIATIONS FROM THE CONTRACT DOCUMENTS ARE TO BE CLEARLY AND VISIBLY NOTED.
- THE DRAWINGS AND SPECIFICATIONS ARE INTENDED TO OUTLINE THE SCOPE OF WORK REQUIRED TO PROVIDE A COMPLETE AND OPERABLE PROJECT AT FINAL ACCEPTANCE. ALL MISCELLANEOUS COMPONENTS, PARTS, FASTENERS, SPLICES, OR OTHER REQUIRED AND INCIDENTAL ITEMS NECESSARY TO PROVIDE A COMPLETED PROJECT ARE TO BE PROVIDED WHETHER OR NOT SPECIFICALLY NOTED IN THE CONTRACT DOCUMENTS.
- IN CASE OF DISCREPANCY AND OR CONFLICT WITHIN THE DRAWINGS OR SPECIFICATIONS, THE CONTRACTOR IS TO NOTIFY THE ARCHITECT OF THE DISCREPANCY, INSTALL THE HIGHER GRADE, MORE STRINGENT PRODUCT OR SYSTEM AND VERIFY WITH ARCHITECT FOR FINAL APPROVAL.
- IN NO CASE ARE WORKING DIMENSIONS TO BE SCALED FROM CONTRACT DOCUMENTS. FIELD VERIFY ALL DIMENSIONS PRIOR TO ORDERING MATERIAL OR FABRICATION OF ITEMS IN CONTRACT.
- CONTRACTOR IS NOT TO DEVIATE FROM THE CONTRACT DOCUMENTS, INDUSTRY STANDARDS, OR EXPLICIT INSTRUCTIONS DUE TO CONTRACTOR OMISSION DURING THE CONSTRUCTION PROCESS WITHOUT AUTHORIZATION FROM THE ARCHITECT. CONTRACTOR IS RESPONSIBLE FOR FURNISHING A COMPLETE TURNKEY PROJECT AS ORIGINALLY INTENDED WITHIN THE CONTRACT DOCUMENTS.
- CONTRACTOR IS TO NOTIFY THE ARCHITECT AND OR ENGINEER TO ALL CONCRETE POURS A MINIMUM OF 48 HOURS PRIOR TO THE EVENT. IN THE EVENT THAT NEITHER THE ARCHITECT OR ENGINEER CAN OBSERVE THE POUR, THE CONTRACTOR IS TO TAKE CONSTRUCTION PHOTOS OF THE WORK SHOWING DETAILS OF ALL REINFORCING, TRENCHING, PILES, ETC. ACCESS TO PHOTOS ARE TO BE GRANTED PRIOR TO POUR AND UPON ARCHITECTS OR ENGINEERS REQUEST.
- CONTRACTOR IS TO NOTIFY ARCHITECT OR ENGINEER TO ALL WORK TO BE CONCEALED AT LEAST 24 HOURS PRIOR TO THE EVENT. IN THE EVENT THAT NEITHER THE ARCHITECT OR ENGINEER CAN OBSERVE THE WORK PRIOR TO CONCEALMENT, THE CONTRACTOR SHALL TAKE CONSTRUCTION PHOTOS OF THE WORK BEING CONCEALED. ACCESS TO PHOTOS ARE TO BE GRANTED PRIOR TO CONCEALMENT AND UPON ARCHITECTS OR ENGINEERS REQUEST.
- CONTRACTOR IS TO NOTIFY ARCHITECT/ENGINEER IMMEDIATELY IF ANY CONFLICTS ARISE FROM DISCOVERED CONDITIONS AT ANY PHASE OF THE PROJECT.
- ANY DEVIATION TO THE CONTRACT DOCUMENTS NOT APPROVED IN WRITING BY THE ARCHITECT SHALL BE THE RESPONSIBILITY OF THE CONTRACTOR TO CORRECT AT THEIR EXPENSE.
- DURING AND UPON COMPLETION OF THE WORK, ALL SURFACES, FIXTURES, AND EQUIPMENT SHALL BE KEPT CLEAN AND FREE OF EXCESS MATERIALS, STAIN, OR DUST AND DEBRIS.
- ALL DOORS ARE TO BE LOCATED WITHIN WALLS, ALLOWING 18" OF WALL CLEARANCE ON THE PULL SIDE OF THE DOOR AT THE LATCH AND 12" OF WALL CLEARANCE ON THE PUSH SIDE OF THE DOOR AT THE LATCH UNLESS NOTED OTHERWISE.
- TRANSITIONS OF DIFFERENT FLOORING MATERIALS AT DOORWAYS SHALL OCCUR AT THE CENTERLINE OF DOORS, AND SHALL BE NO GREATER THAN ADA REQUIREMENTS.
- ALL WORK TO BE INSTALLED TO MOST STRINGENT LOCAL, STATE, AND NATIONAL CODES INCLUDING ACCESSIBILITY REQUIREMENTS.
- CONTRACTOR SHALL NOT SCALE THESE DRAWINGS FOR CONSTRUCTION PURPOSES. IN THE EVENT OF OMISSION OF A NECESSARY DIMENSION OR INFORMATION, CONTRACTOR SHALL NOTIFY ARCHITECT. ALL PLAN DETAILS AND WALL SECTIONS ARE ASSUMED TO BE TYPICAL CONDITIONS UNLESS NOTED OTHERWISE.
- VERIFY ALL DIMENSIONS, CONDITIONS, AND GRADES AT JOB SITE. ALL CONTRACTORS AND SUB-CONTRACTORS SHALL COORDINATE THEIR WORK WITH OTHER TRADES AND REPORT DISCREPANCIES PRIOR TO INSTALLATION OF THEIR MATERIAL AND SYSTEMS.
- VERIFY SIZE, LOCATION, AND CHARACTERISTICS OF ALL EQUIPMENT TO BE FURNISHED WITH MANUFACTURER'S OR SUPPLIERS BEFORE BEGINNING CONSTRUCTION.
- VERIFY SIZES AND LOCATIONS OF ALL OPENINGS FOR MECHANICAL AND ELECTRICAL EQUIPMENT. CONSTRUCTION DETAILS NOT SPECIFICALLY SHOWN USE RECOMMENDED MANUFACTURER INSTALLATION DETAILS.
- CEILING HEIGHTS SHOWN IN THE ROOM FINISH SCHEDULE ARE REFERENCED TO THE FINISHED FLOOR ELEVATION OF THE ROOM OR SPACE SHOWN.
- ADD SUFFICIENT BLOCKING IN STUD WALLS TO SUPPORT ALL ITEMS OR EQUIPMENT SHOWN OR SPECIFIED BE ATTACHED TO THE WALLS. PROVIDE ADDITIONAL STRUCTURAL SUPPORT ANGLES, CHANNELS, MISC. METALS) WITHIN WALLS WHERE THE WEIGHT OF ATTACHED ITEMS OR EQUIPMENT IS TOO GREAT TO BE SUPPORTED BY METAL STUDS. COORDINATE LOCATIONS OF ANY OWNER PROVIDED EQUIPMENT.
- COORDINATE WITH MECHANICAL FOR LOCATIONS OF ALL FLOOR DRAINS AND TRENCHES.
- ALL PLUMBING WET WALLS, EXCLUDING CHASES, SHALL BE FRAMED WITH A MINIMUM OF 6" METAL STUDS..

25. CONTRACTOR TO CONTACT ANY AND ALL LOCAL UTILITIES, OBTAIN ALL REQUIRED PERMITS, PROVIDE ALL FEES ASSOCIATED WITH THE REQUIRED CONSTRUCTION AND PERMITTING. THIS INCLUDES BUT IS NOT LIMITED TO TAP-INS, UTILITY EXTENSIONS, INSPECTIONS, ETC. THE CONTRACTOR IS RESPONSIBLE FOR OBTAINING ALL PERMITS AND ALL PERMIT AND INSPECTION COSTS.

26. THE CONTRACTOR SHALL REMOVE ALL CONSTRUCTION TRASH AND DEBRIS DAILY.

27. MASONRY CONSTRUCTION REQUIRES SKILLED MASONRY THAT STRICTLY ADHERE TO THE BEST PRACTICES, STANDARDS AND DETAILS OF THE NATIONAL CONCRETE MASONRY ASSOCIATION, AS WELL AS SPECIFICATIONS AND DRAWING DETAILS.

28. A MASONRY MANUFACTURER REPRESENTATIVE SHALL BE PRESENT AT MASONRY PRE-INSTALLATION MEETING TO SET STANDARDS, REVIEW INSTALLATION DETAILS AND ANSWER ANY QUESTIONS PRIOR TO COMMENCING ANY MASONRY CONSTRUCTION ON THIS PROJECT.

29. SEAL ALL PENETRATIONS IN FIRE RATED WALLS WITH AN APPROVED SEALANT. USE EXPANDABLE FIRE STOPPING AT SLAB EDGES AND WHERE WALLS GO TO DECK ABOVE..

TITLE

Sheet Number	Sheet Name
T-100	TITLE SHEET

GENERAL

Sheet Number	Sheet Name
G001	SURVEY
G002	UNIT COUNT
G003	PHOTOS - EXISTING SITE

LANDSCAPE PLAN

Sheet #	Sheet Name
LS-1	LANDSCAPE PLANTING PLAN
LS-2	LANDSCAPE SPECS AND DETAILS

SITE PLAN

Sheet #	Sheet Name
SP-1	PRELIMINARY SITE PLAN

ARCHITECTURAL

Sheet Number	Sheet Name
A002	SITE SECTION & FENCE ELEVATION
A101	FIRST FLOOR PLAN
A102	SECOND FLOOR PLAN
A103	THIRD FLOOR PLAN
A121	ROOF PLAN
A201	BUILDING ELEVATIONS
A202	BUILDING ELEVATIONS - COLOR

ELECTRICAL

Sheet Number	Sheet Name
E100	ELECTRICAL SITE PLAN



ABBREVIATIONS

ABBREV.	DESCRIPTION	ABBREV.	DESCRIPTION
ACT	ACOUSTIC CEILING TILE	H.R.	HANDRAIL
ADJ	ADJACENT	LAV.	LAVATORY
AL/ALUM	ALUMINUM	MECH.	MECHANICAL
APF	ABOVE FINISH FLOOR	MFG	MANUFACTURER
BLDG	BUILDING	M.O.	MASONRY OPENING
BD	BOARD	MISC.	MISCELLANEOUS
CONC.	CONCRETE	MTL	METAL
CHLORN	CHLORINE	N/A	NOT APPLICABLE
CL.F.	CHAIN LINK FENCE	N/C	NOT IN CONTRACT
CLG	CEILING	O.C.	ON CENTER
CMU	CONCRETE MASONRY UNIT	OHD	OVERHEAD COILING DOOR
CONT	CONTINUOUS	PLAM	PLASTIC LAMINATE
CPT	CARPET	REQ	REQUIRED
CU	COOLING UNIT	PREP	PREPARATION
CT	CERAMIC TILE	SCH.	SCHEDULE
CTB	CERAMIC TILE BASE	PW	PLYWOOD
DM	DIMETER	SHM	SIMILAR
DS	DOWNSPOUT	SPEC(S)	SPECIFICATION(S)
DWG	DRAWING	SS	STAINLESS STEEL
EHL	ELECTRIC HYDRAULIC LIFT	STL	STEEL
ELEC	ELECTRICAL	T.O.S.	TOP OF STEEL
EXIST	EXISTING	TYPC	TYPICAL
FFL	FINISH FLOOR LEVEL	VCT	VINYL COMPOSITION TILE
FRP	FIBERGLASS REINFORCED PANEL	VERT	VERTICAL
FLR	FLOOR	VOU	VERIFY ON JOB
F.D.	FLOOR DRAIN	WB	W/IN
F.E.	FIRE EXTINGUISHER	WDSC.	WOOD DOOR SOLID CORE
GALV	GALVANIZED	W.F.	WATER FOUNTAIN
GBGR	GYPSPUM GREEN BOARD	E.S.	EXIT SIGN
GYP	GYPSPUM BOARD	RTU	ROOFTOP UNIT
PB	PIPE BOLLARD		
HM	HOLLOW METAL		
HORIZ	HORIZONTAL		

APARTMENTS | 3800 TEXAS DRIVE

SHEET TITLE
TITLE SHEET

DRAWN BY:
Author

CHECKED BY:
Checker

APPROVED BY:
Approver

PROJ. NO. 23-104


DATE: 11.07.2025

SHEET NO.

T-100

OF SHEETS


LINFIELD, HUNTER & JUNIUS, INC.
PROFESSIONAL ENGINEERS,
ARCHITECTS AND SURVEYORS
3608 18th Street, Suite 200
Metairie, Louisiana 70002

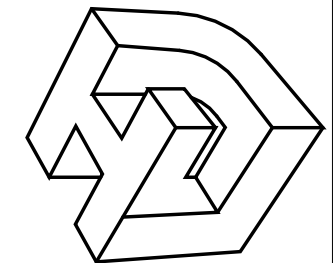

PRELIMINARY
FOR REVIEW ONLY
NOT FOR CONSTRUCTION
THIS DRAWING IS SUBJECT TO
REVISION, ALTERATION & DELETION

© 2025 by Linfield, Hunter & Junius, Inc.


BOUNDARY SURVEY
LOTS H-1, H-2, H-3, & H-4
GARDEN OAK SUBDIVISION
SQUARE H
ORLEANS PARISH
LOUISIANA

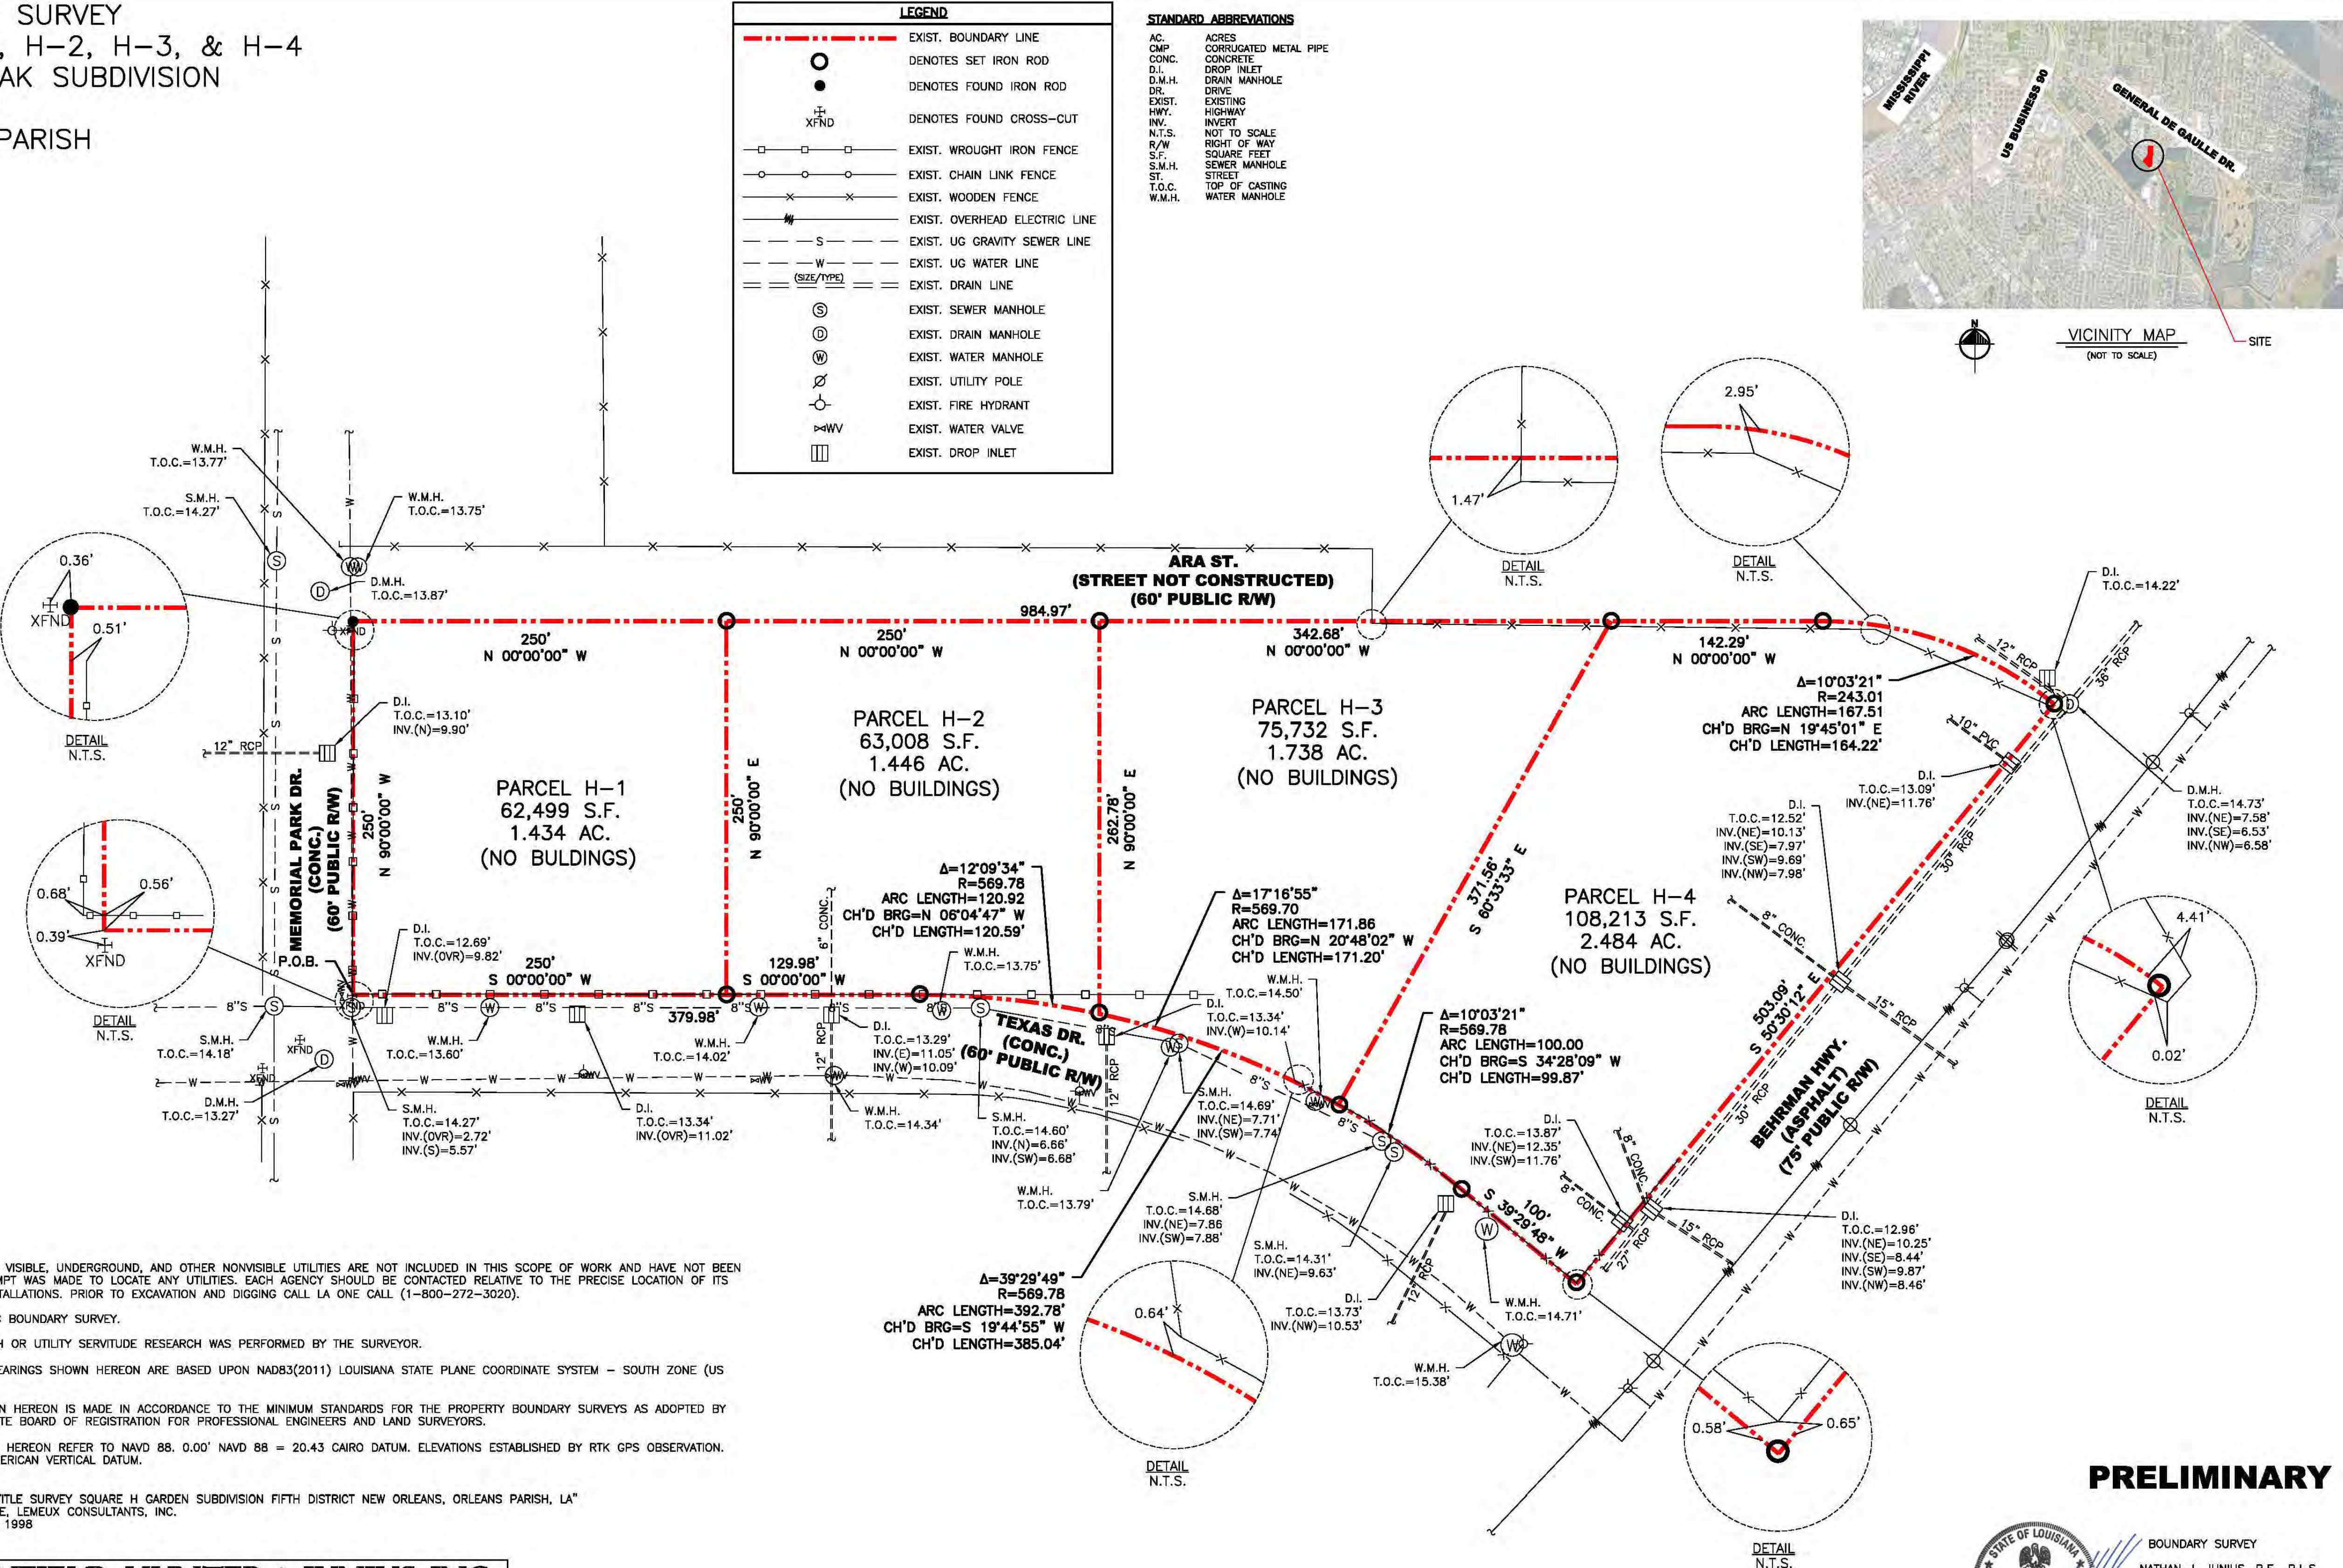

- GENERAL NOTES:**
- THE LOCATIONS OF VISIBLE, UNDERGROUND, AND OTHER NONVISIBLE UTILITIES ARE NOT INCLUDED IN THIS SCOPE OF WORK AND HAVE NOT BEEN PLOTTED. NO ATTEMPT WAS MADE TO LOCATE ANY UTILITIES. EACH AGENCY SHOULD BE CONTACTED RELATIVE TO THE PRECISE LOCATION OF ITS UNDERGROUND INSTALLATIONS. PRIOR TO EXCAVATION AND DIGGING CALL LA ONE CALL (1-800-272-3020).
 - THIS IS A CLASS C BOUNDARY SURVEY.
 - NO TITLE RESEARCH OR UTILITY SERVITUDE RESEARCH WAS PERFORMED BY THE SURVEYOR.
 - THE REFERENCE BEARINGS SHOWN HEREON ARE BASED UPON NAD83(2011) LOUISIANA STATE PLANE COORDINATE SYSTEM - SOUTH ZONE (US SURVEY FEET).
 - THE SURVEY SHOWN HEREON IS MADE IN ACCORDANCE TO THE MINIMUM STANDARDS FOR THE PROPERTY BOUNDARY SURVEYS AS ADOPTED BY THE LOUISIANA STATE BOARD OF REGISTRATION FOR PROFESSIONAL ENGINEERS AND LAND SURVEYORS.
 - ELEVATIONS SHOWN HEREON REFER TO NAVD 88. 0.00' NAVD 88 = 20.43 CAIRO DATUM. ELEVATIONS ESTABLISHED BY RTK GPS OBSERVATION. NAVD = NORTH AMERICAN VERTICAL DATUM.
 - REFERENCE MAPS
A. "ALIA/ACSM LAND TITLE SURVEY SQUARE H GARDEN SUBDIVISION FIFTH DISTRICT NEW ORLEANS, ORLEANS PARISH, LA"
BY: KREBS, LASALLE, LEMEXU CONSULTANTS, INC.
DATED: MARCH 17, 1998

LINFELD, HUNTER & JUNIUS, INC.
PROFESSIONAL ENGINEERS, ARCHITECTS,
AND SURVEYORS
3608 18th Street, Suite 200
Metairie, Louisiana 70002

© 2023 by Linfield, Hunter & Junius, Inc.

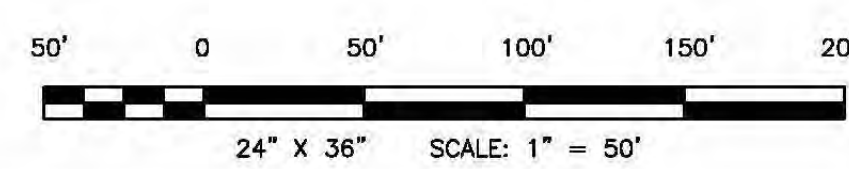

PRELIMINARY

BOUNDARY SURVEY
NATHAN J. JUNIUS, P.E., P.L.S.
DATE: 12/07/2023
LH&J JOB No. 23-104
(504) 833-5300

LINFELD, HUNTER & JUNIUS, INC.
PROFESSIONAL ENGINEERS,
ARCHITECTS AND SURVEYORS
3608 18th Street, Suite 200
Metairie, Louisiana 70002

PRELIMINARY
FOR REVIEW ONLY
NOT FOR CONSTRUCTION
THIS DRAWING IS SUBJECT TO
REVISION, ALTERATION & DELETION


APARTMENTS | 3800 TEXAS DRIVE

SHEET TITLE: SURVEY
DRAWN BY: Author
CHECKED BY: Checker
APPROVED BY: Approver

PROJ. NO. 23-104
DATE: 11.07.2025
SHEET NO.

G001
OF SHEETS

© 2025 by Linfield, Hunter & Junius, Inc.

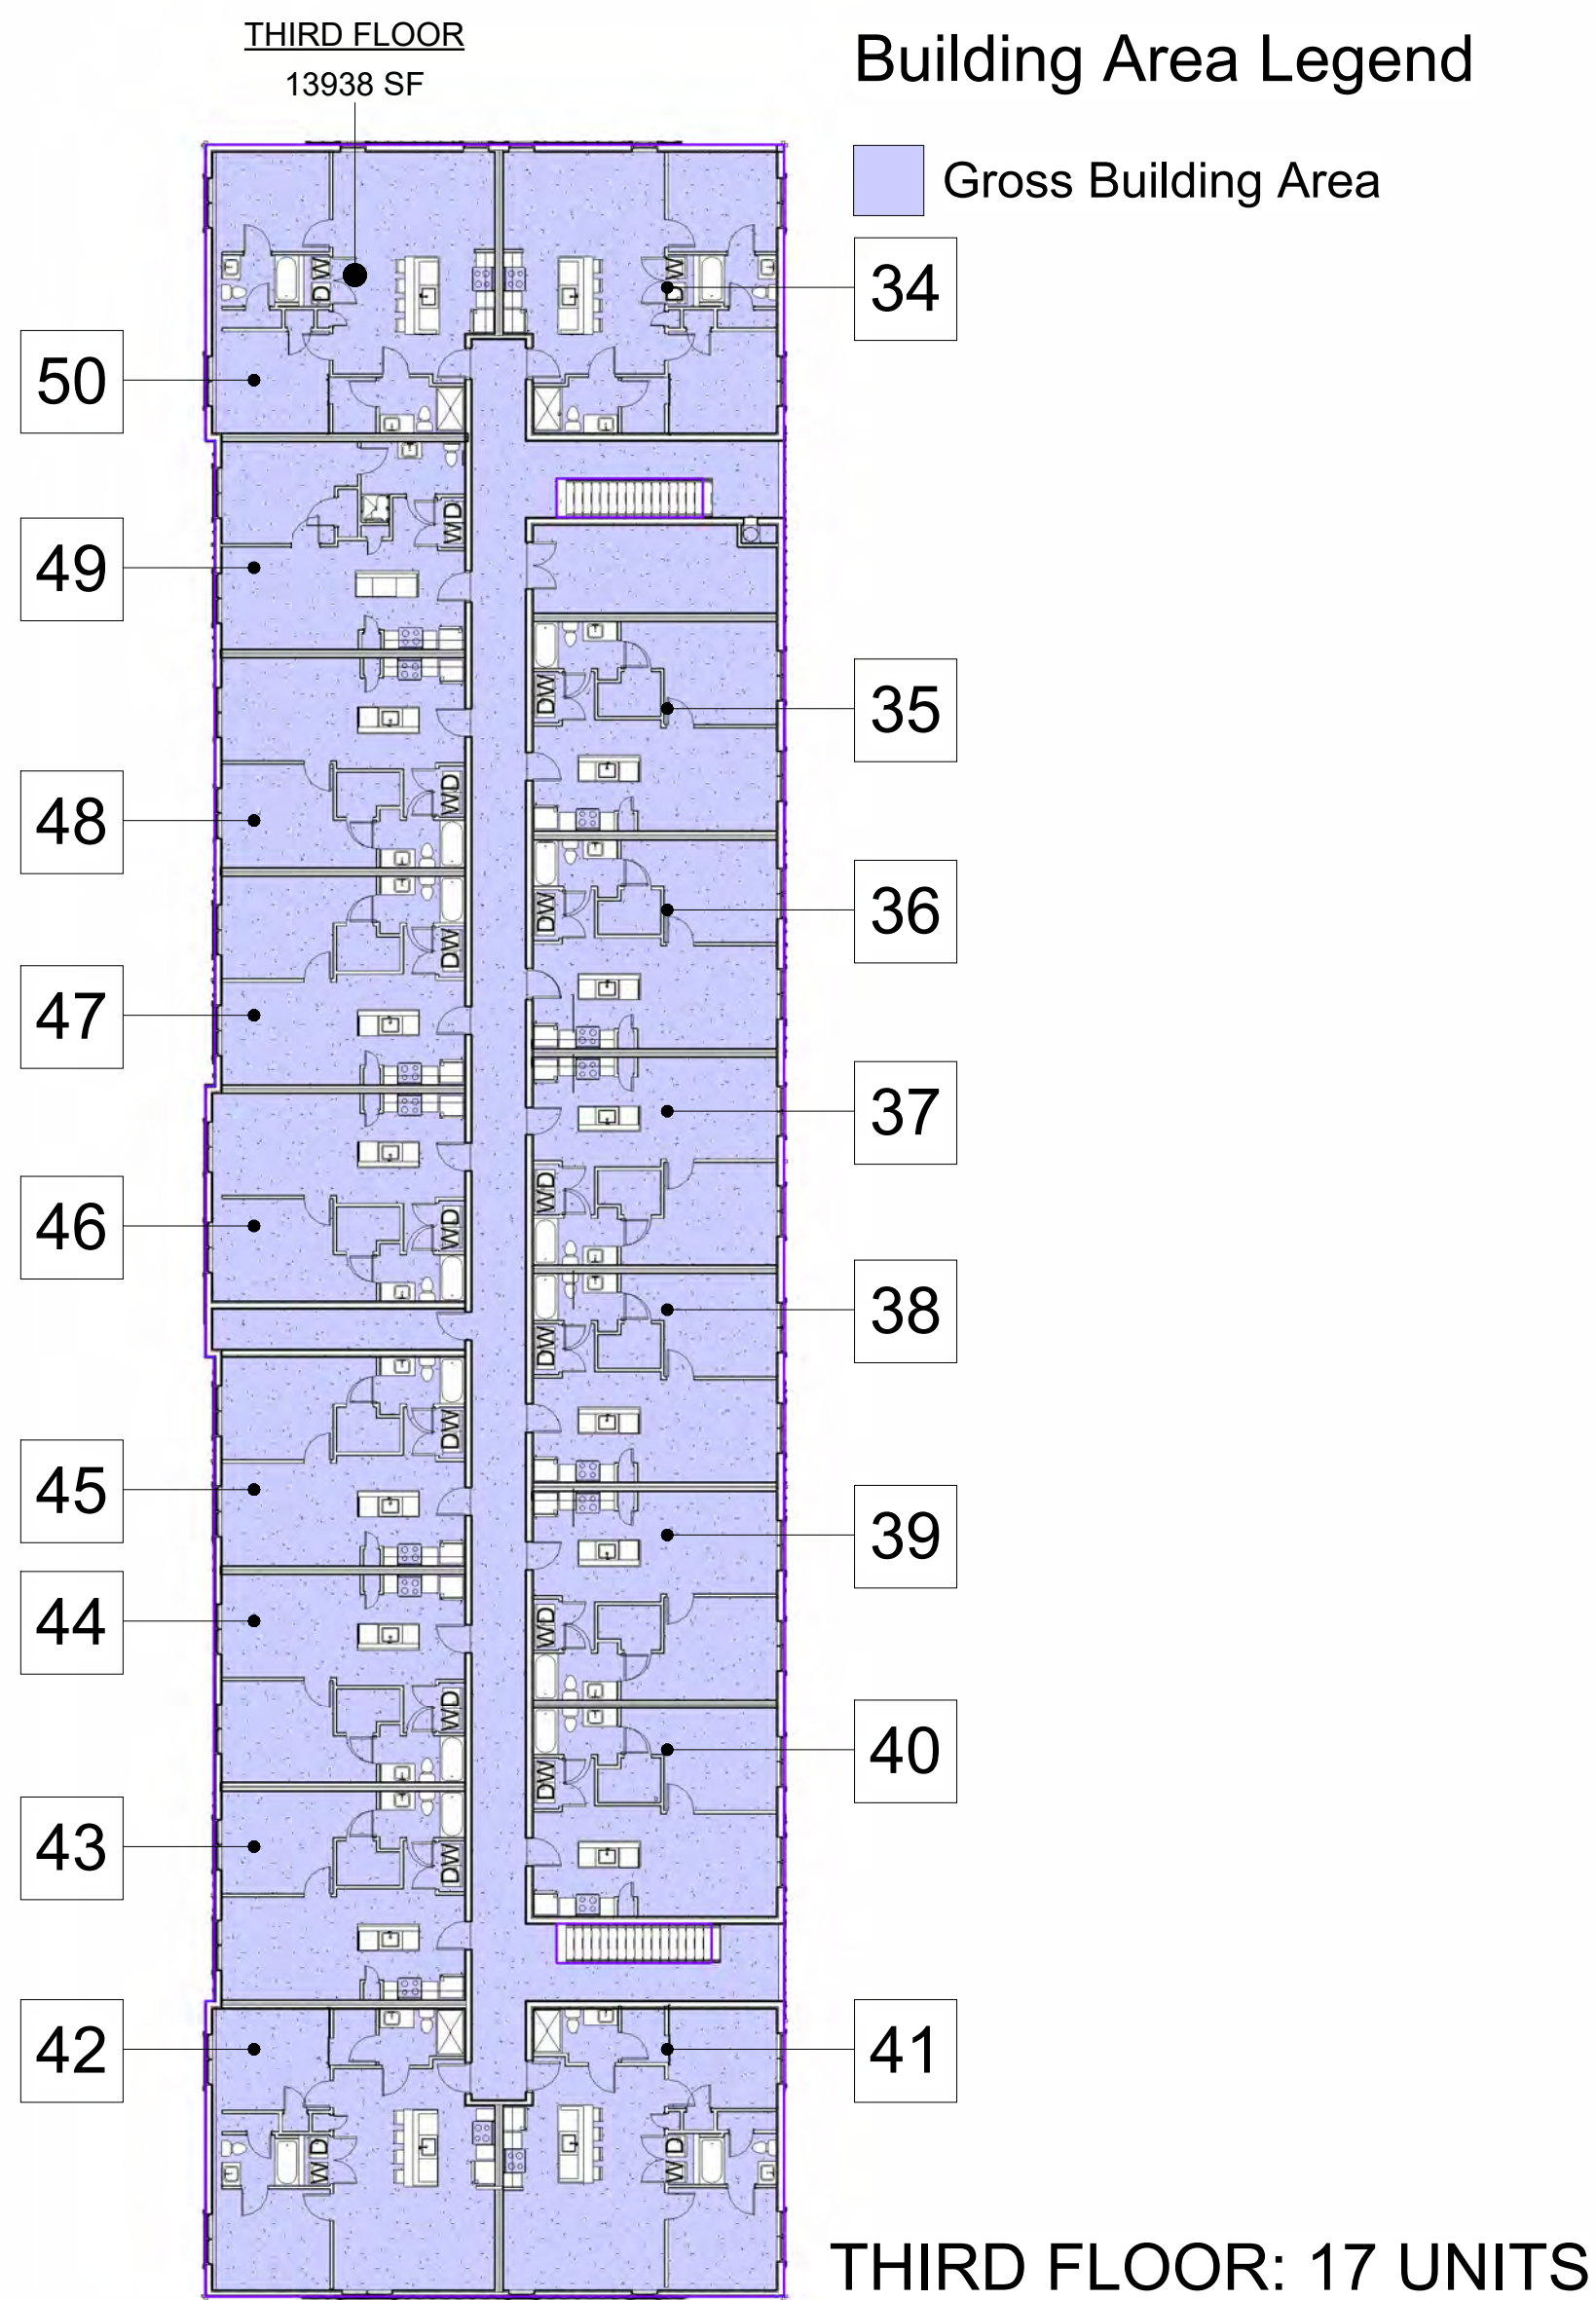

③ LEVEL 3
1" = 20'-0"


NARRATIVE

The proposed development will provide a 50-unit multiple family development with a parking lot. The proposed building is oriented towards the public or private street in terms of architectural interest and materials and building access. It also provides a clearly articulated entry from the public sidewalk at the front elevation.


Driveways have been configured to minimize the reduction of on-street parking spaces. Safe pedestrian access from adjacent properties is accounted for - the site maintains safe pedestrian access to the development from the street and from any parking areas, as well as internal to the site. Sidewalks also extend to the lot line and connect to existing sidewalks on abutting property if feasible.

Side walls of our proposal that faces the street is designed with multiple windows matching those on the front elevation. There is no parking between the street line and the front building line. Since this is a corner lot, there is no parking within the corner side yard within five (5) feet of the front lot line. Driveways are consolidated, where possible, in order to reduce curb cuts. The following materials: Exterior insulation finish systems, Stuccato board, and Vinyl are not used for the predominant surface finish material in the construction.

Consistency in the roofline is achieved by using similar roof type, slope, materials and details to ensure that the proposal is compatible with the surrounding neighborhood character. Facade is designed to be viewed from multiple directions and with consistent materials that wraps around all facades. There is a unifying architectural theme for the proposal, utilizing a common vocabulary of architectural forms, elements, materials, and colors around the entire structure.

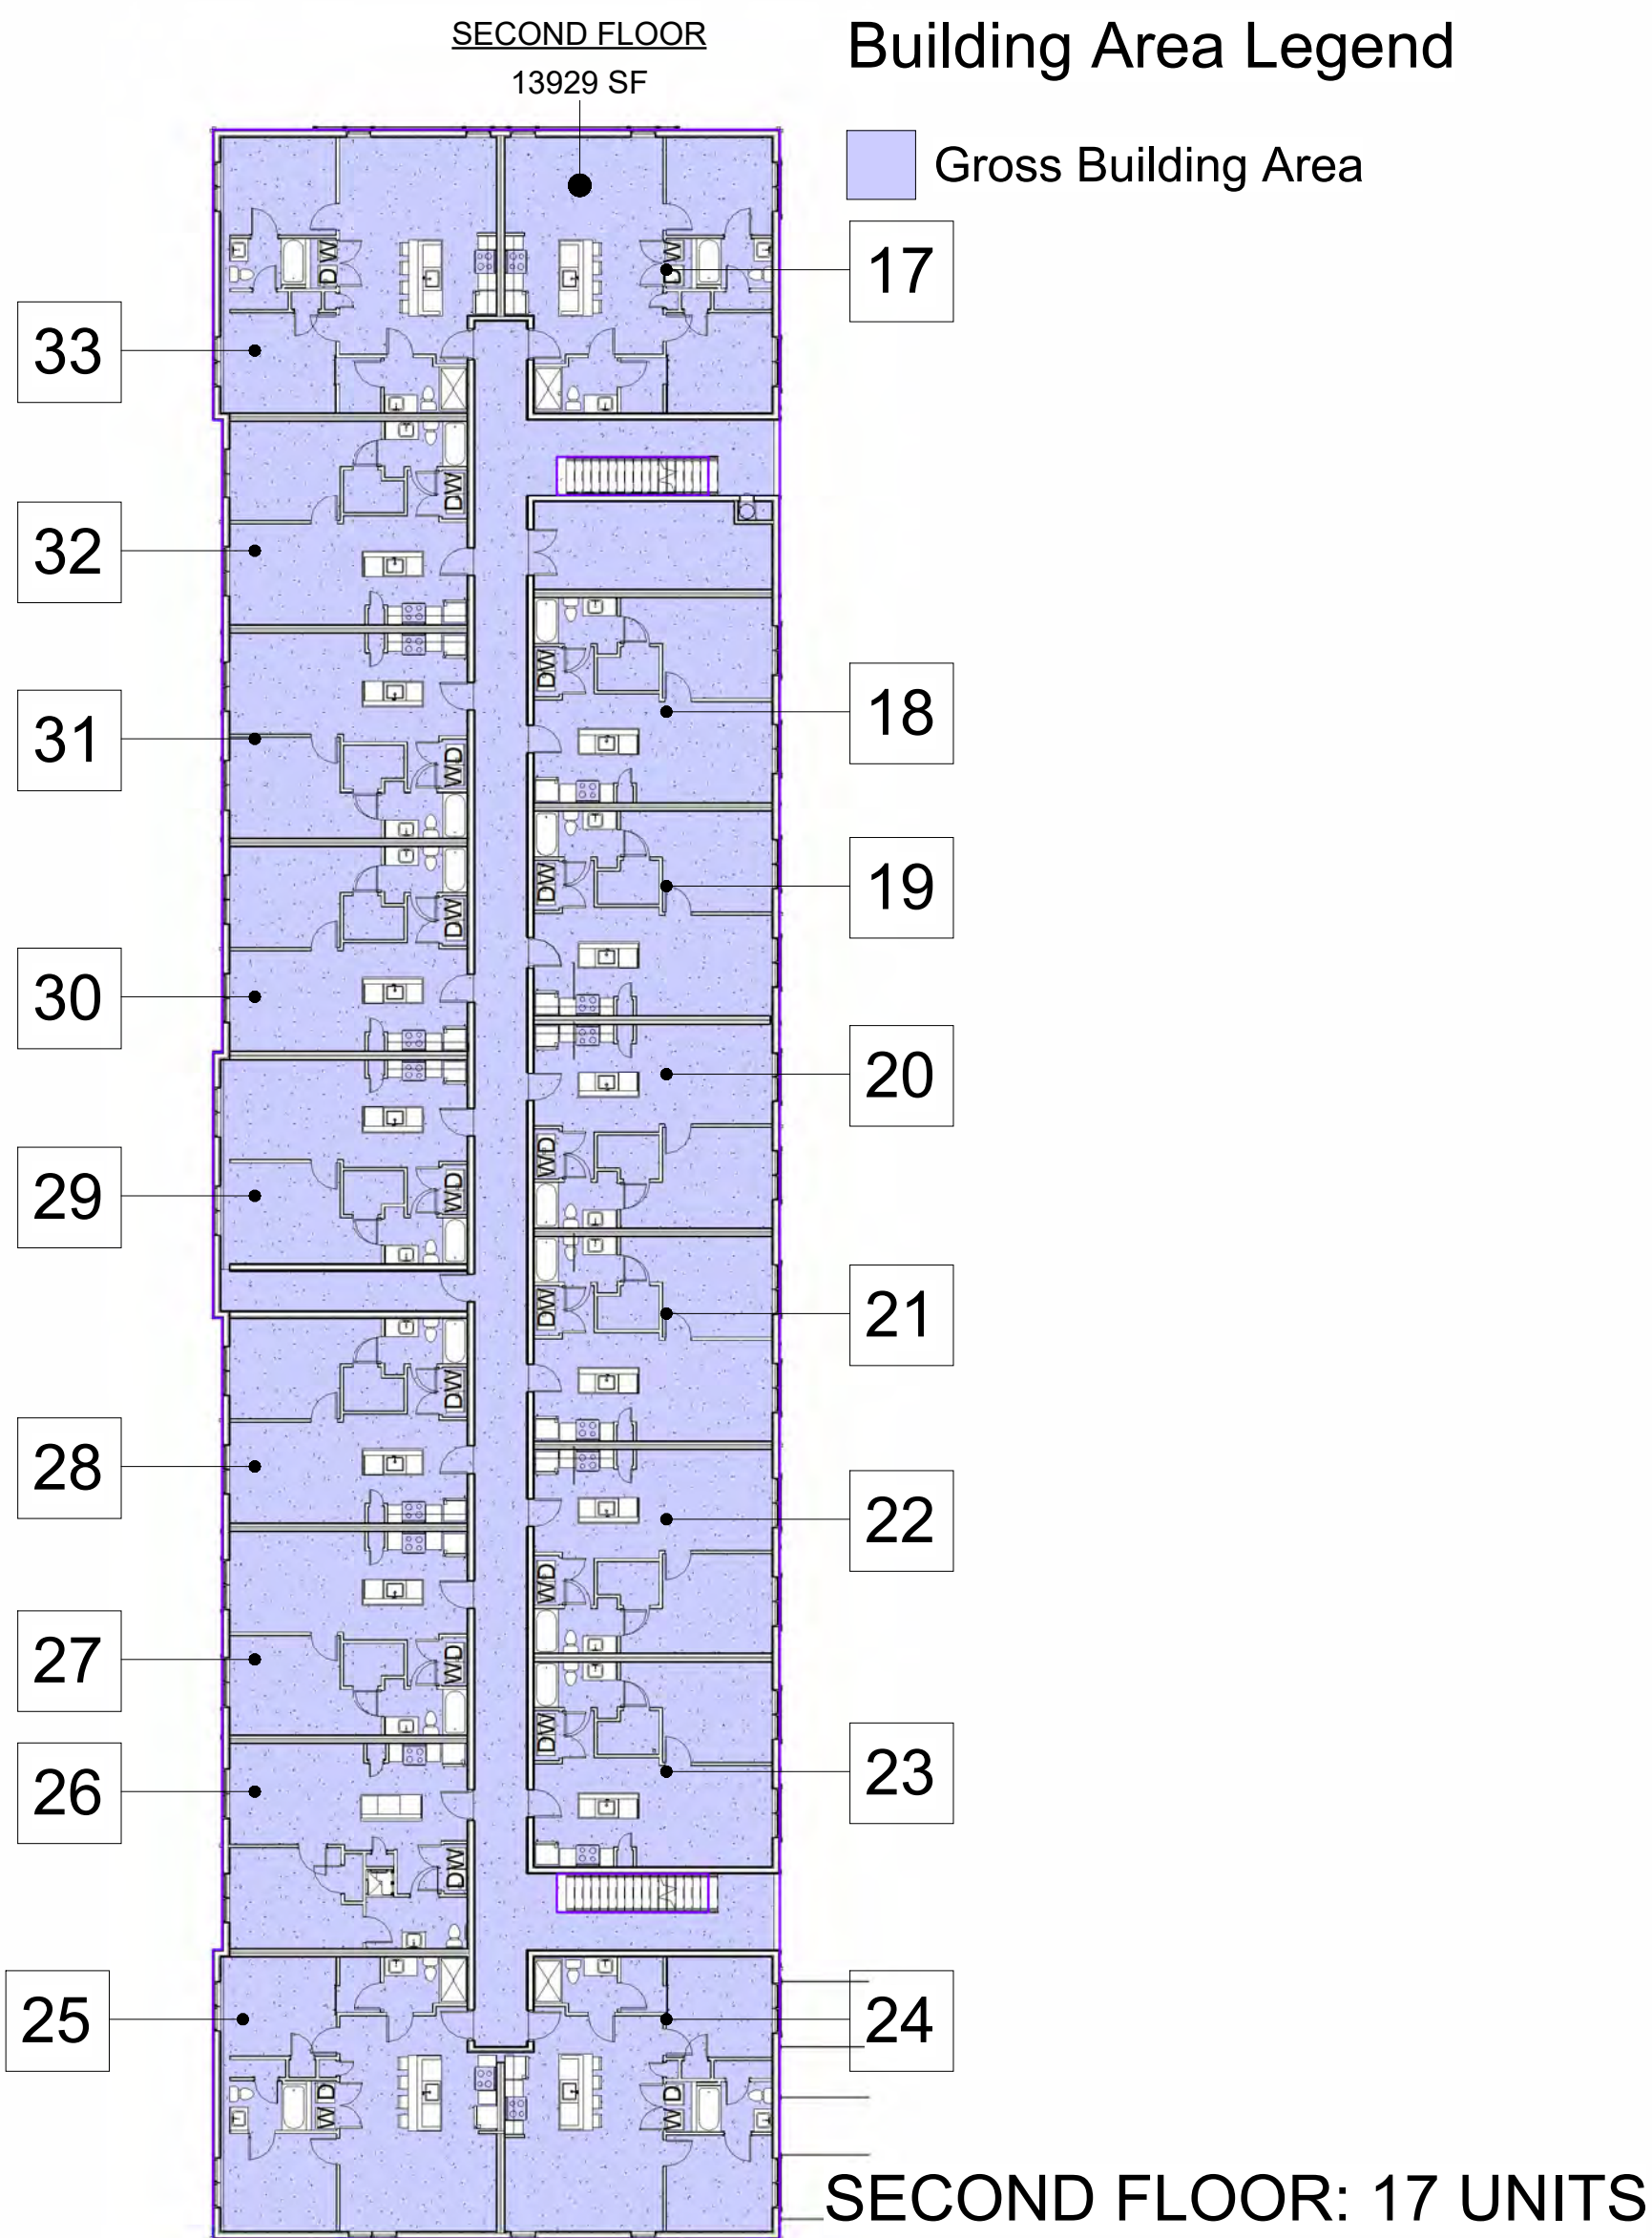

② LEVEL 2
1" = 20'-0"

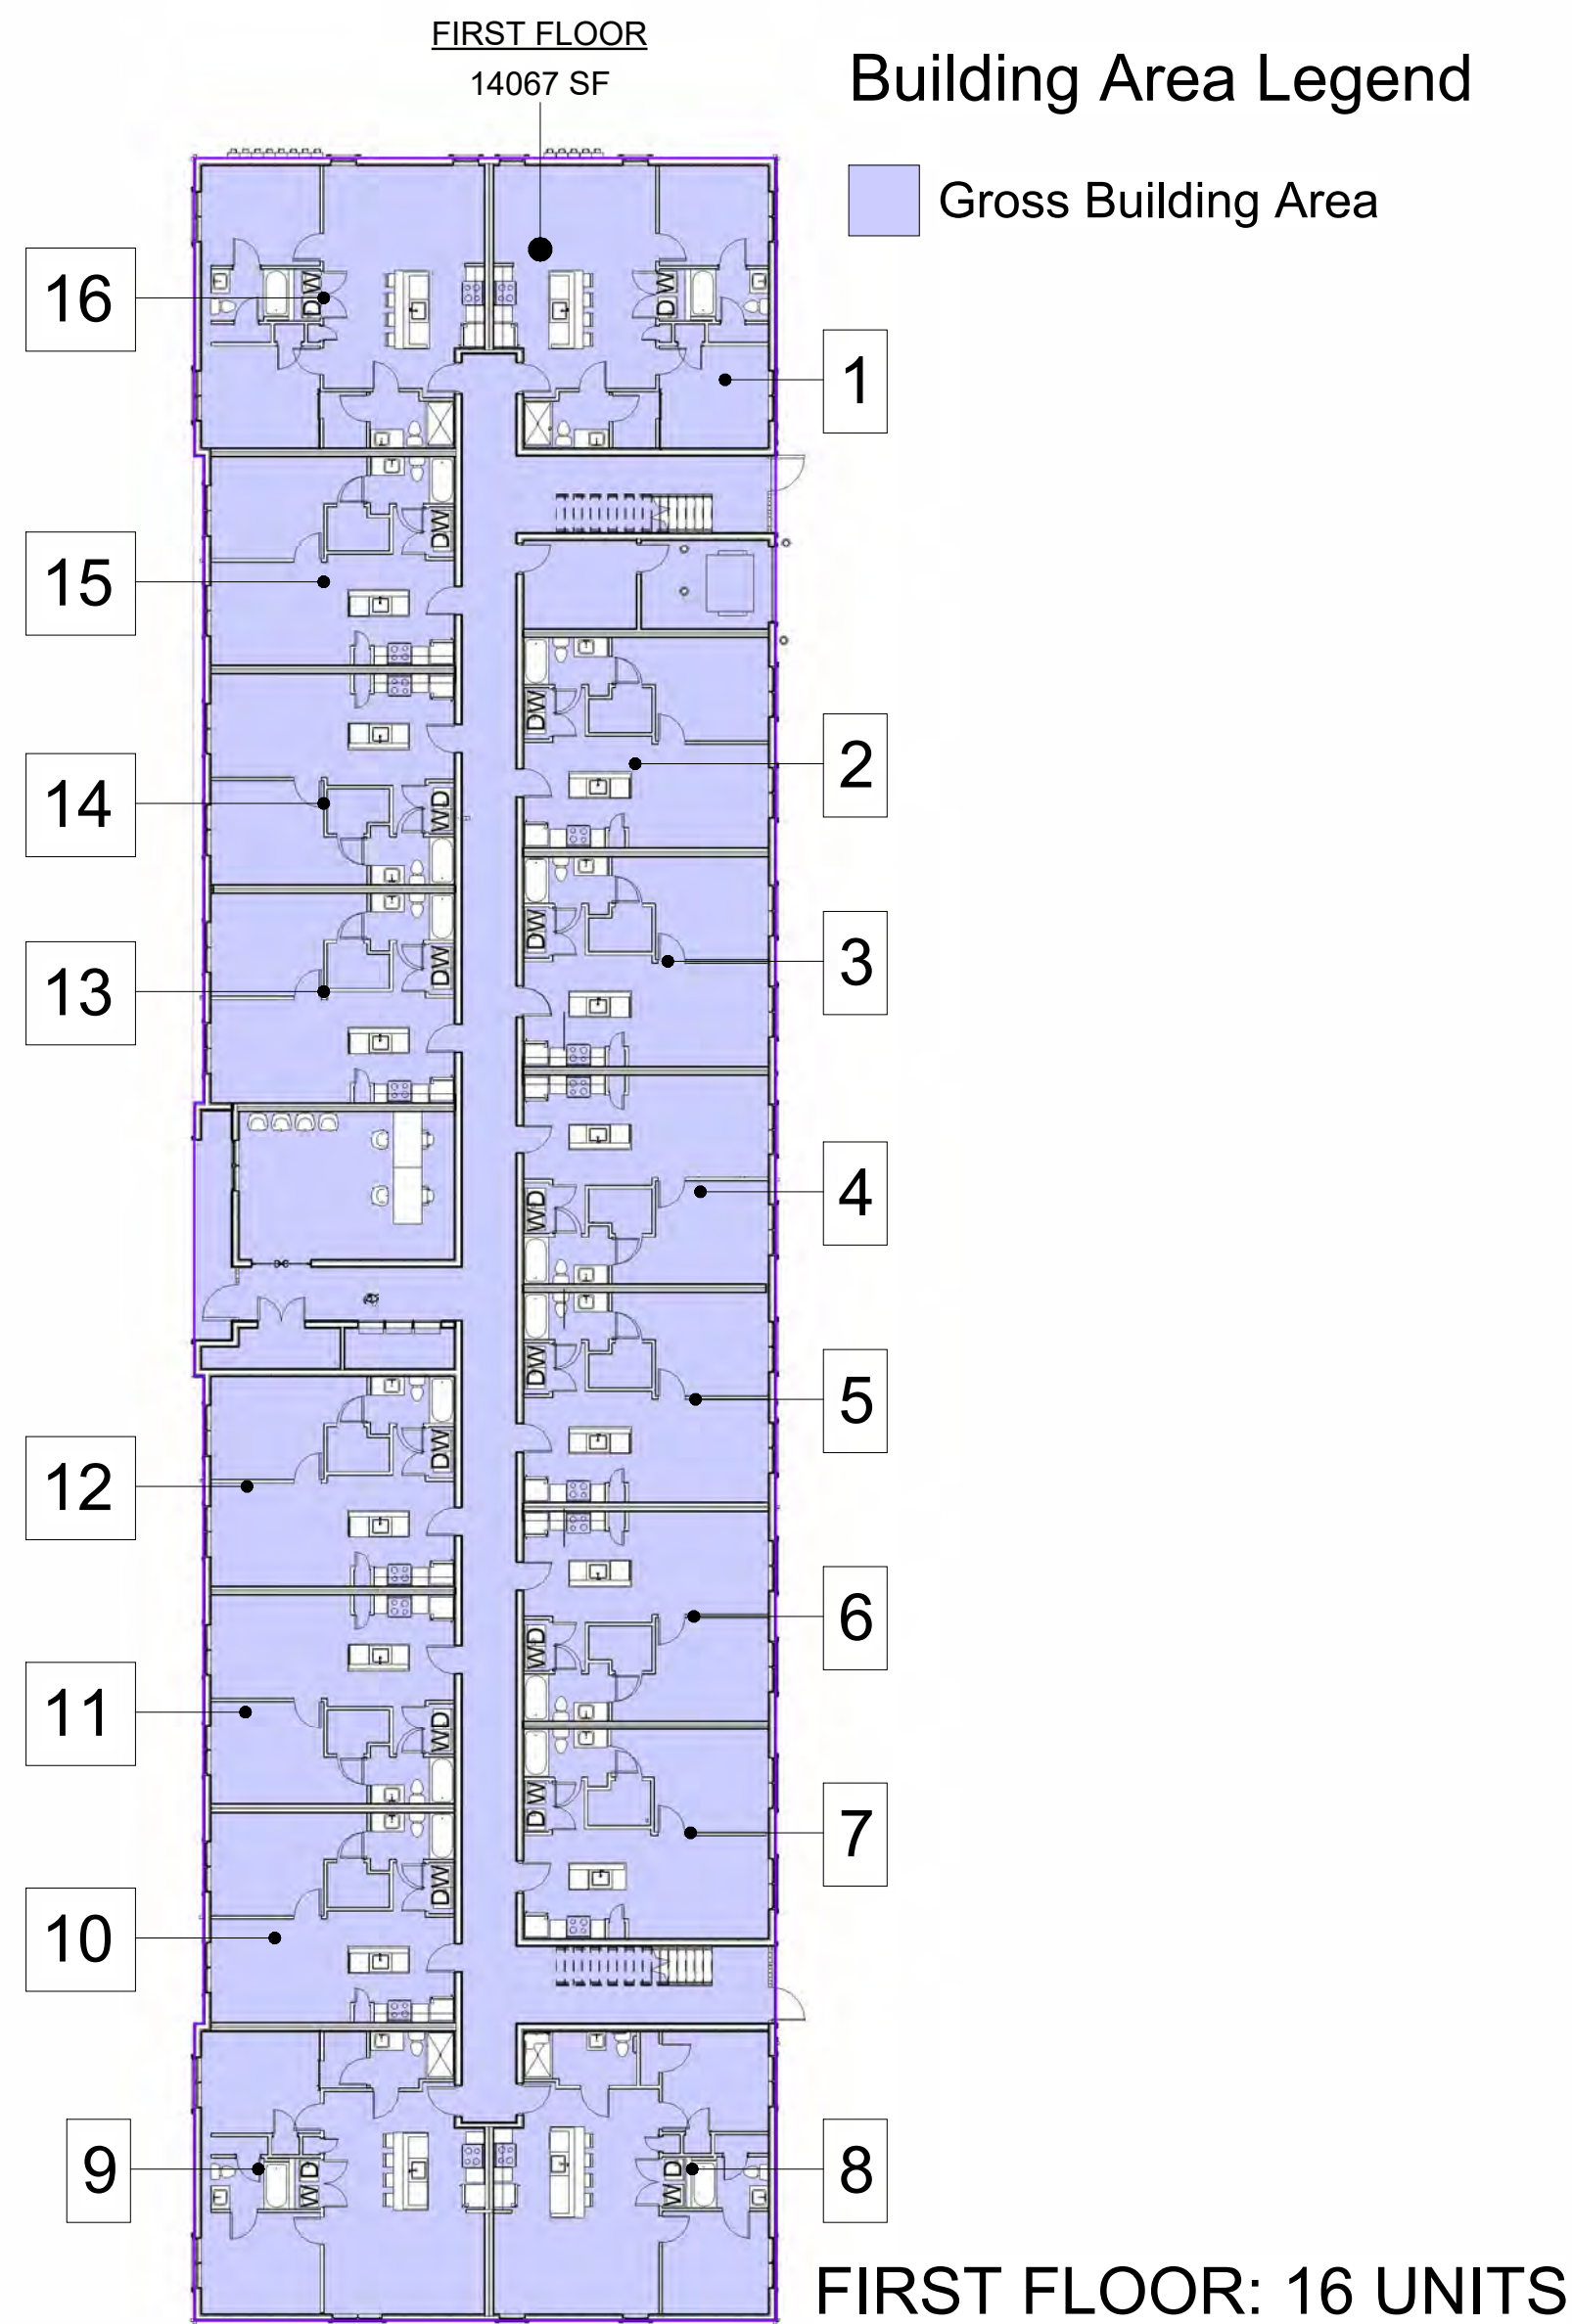

① LEVEL 1
1" = 20'-0"

TOTAL OVERALL: 50 UNITS


BUILDING GROSS AREA		
Name	Area Type	Area
FIRST FLOOR	Gross Building Area	14067 SF
SECOND FLOOR	Gross Building Area	13929 SF
THIRD FLOOR	Gross Building Area	13938 SF
		41934 SF

PRELIMINARY
FOR REVIEW ONLY
NOT FOR CONSTRUCTION
THIS DRAWING IS SUBJECT TO
REVISION, ALTERATION & DELETION

APARTMENTS | 3800 TEXAS DRIVE

PROJ. NO. 23-104
DATE: 11.07.2025
SHEET NO.

G002
OF SHEETS

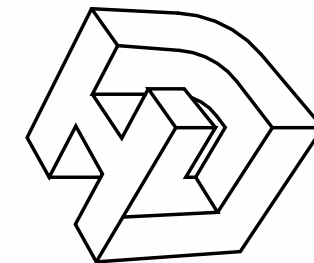

LINFIELD, HUNTER & JUNIUS, INC.
PROFESSIONAL ENGINEERS,
ARCHITECTS AND SURVEYORS
3608 18th Street, Suite 200
Metairie, Louisiana 70002

© 2025 by Linfield, Hunter & Junius, Inc.



① SITE PHOTOS
1 1/2" = 1'-0"

APARTMENTS | 3800 TEXAS DRIVE

SHEET TITLE
PHOTOS - EXISTING SITE

DRAWN BY:
Author

CHECKED BY:
Checker

APPROVED BY:
Approver

PROJ. NO. 23-104


DATE: 11.07.2025

SHEET NO.

G003


OF SHEETS

PRELIMINARY
FOR REVIEW ONLY
NOT FOR CONSTRUCTION
THIS DRAWING IS SUBJECT TO
REVISION, ALTERATION & DELETION

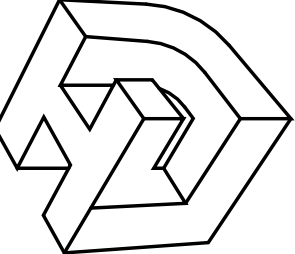

LINFIELD, HUNTER & JUNIUS, INC.
PROFESSIONAL ENGINEERS,
ARCHITECTS AND SURVEYORS
3608 18th Street, Suite 200
Metairie, Louisiana 70002

© 2025 by Linfield, Hunter & Junius, Inc.

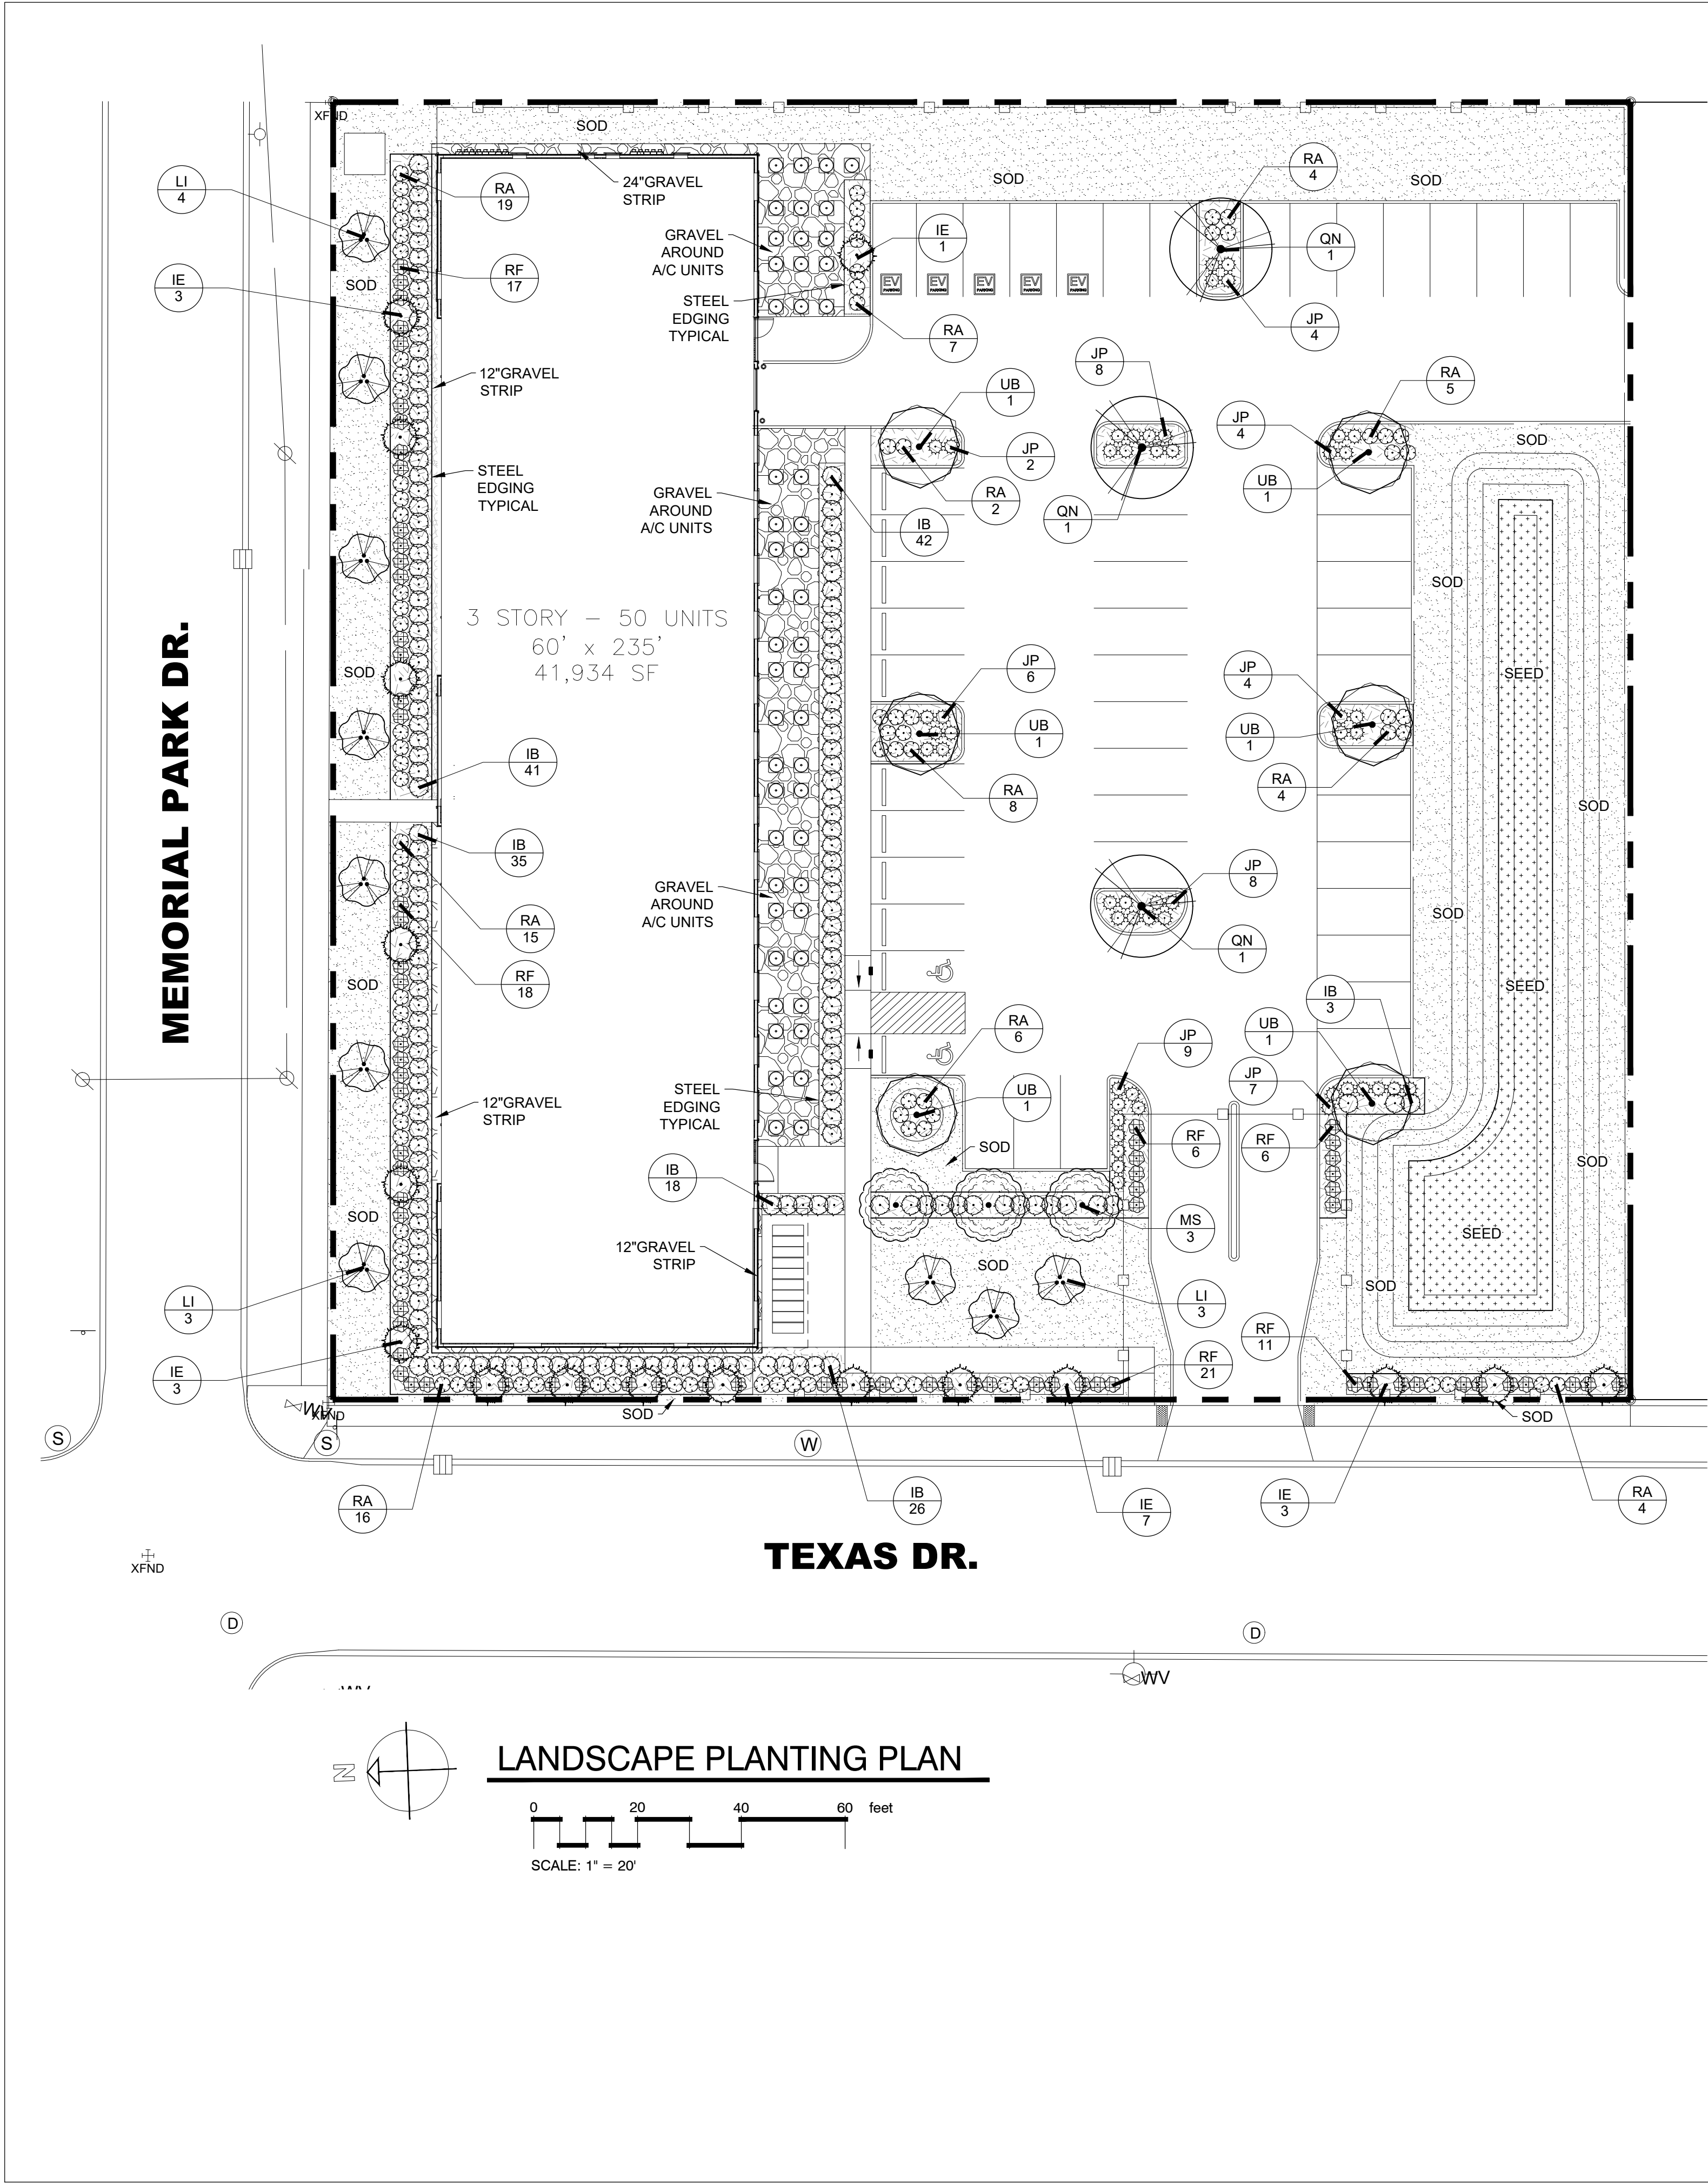

LANDSCAPE CALCULATIONS

Building Foundation Landscape

A SINGLE HEDGE ROW IS REQUIRED, PLANTED WITH ONE (1) SHRUB EVERY THIRTY-SIX (36) INCHES ON CENTER

Front Yard Landscape

ONE (1) PLANT UNIT PER ONE-HUNDRED (100) LINEAR FEET SHALL BE PROVIDED
UNIT C = 2 ORNAMENTAL TREES 3 EVERGREEN TREES 25 SHRUBS
500/100=5 UNITS 10 ORNAMENTAL TREES 15 EVERGREEN TREES 125 SHRUBS REQUIRED


Parking Lot Landscape

5' LANDSCAPE STRIP ABUTTING PUBLIC ROW (1) SHRUB EVERY THIRTY-SIX (36) INCHES ON CENTER + 1 TREE PER 40 LF
1 SHADE TREE PER LANDSCAPE ISLAND WITH 75% SHRUBS PER ISLAND



ALPHONSE BARCIA III
LANDSCAPE ARCHITECT LLC.

562 CLAYTON COURT
SLIDELL, LOUISIANA 70461
BARCIADESIGNS@GMAIL.COM
(985) 960-0429

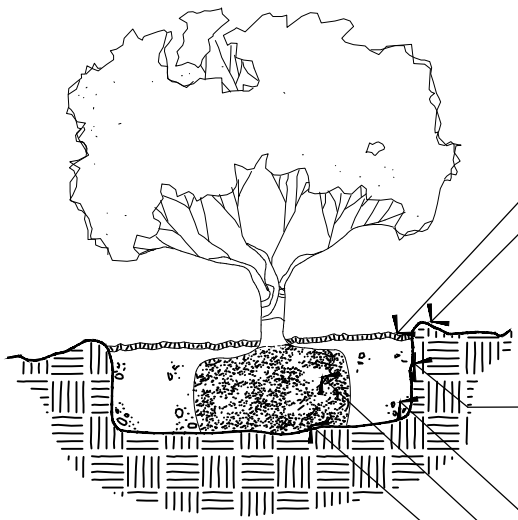


3" PINE BARK MULCH
FORM SAUCER WITH 3" CONTINUOUS EARTHEN RIM AROUND PLANTING HOLE

PLANTING PIT DEPTH SHALL EQUAL DEPTH OF ROOT BALL. PLANTING PIT WIDTH SHALL BE TWICE THE DIAMETER FOR ROOT BALLS 2' AND UNDER, OR 2' LARGER IN DIAMETER FOR ROOT BALLS OVER 2'

BACKFILL MEDIUM SHOULD BE A MIXTURE OF 50% REMOVED MATERIAL WITH 50% MIXTURE OF PREPARED PLANTING SOIL MIXTURE
PLANT TOP OF ROOT BALL EVEN WITH FINISHED GRADE
PLACE ROOT BALL AT BOTTOM OF PLANTING PIT ON UNDISTURBED SUBGRADE

1 SHRUB PLANTING DETAIL

LS-1 N.T.S.

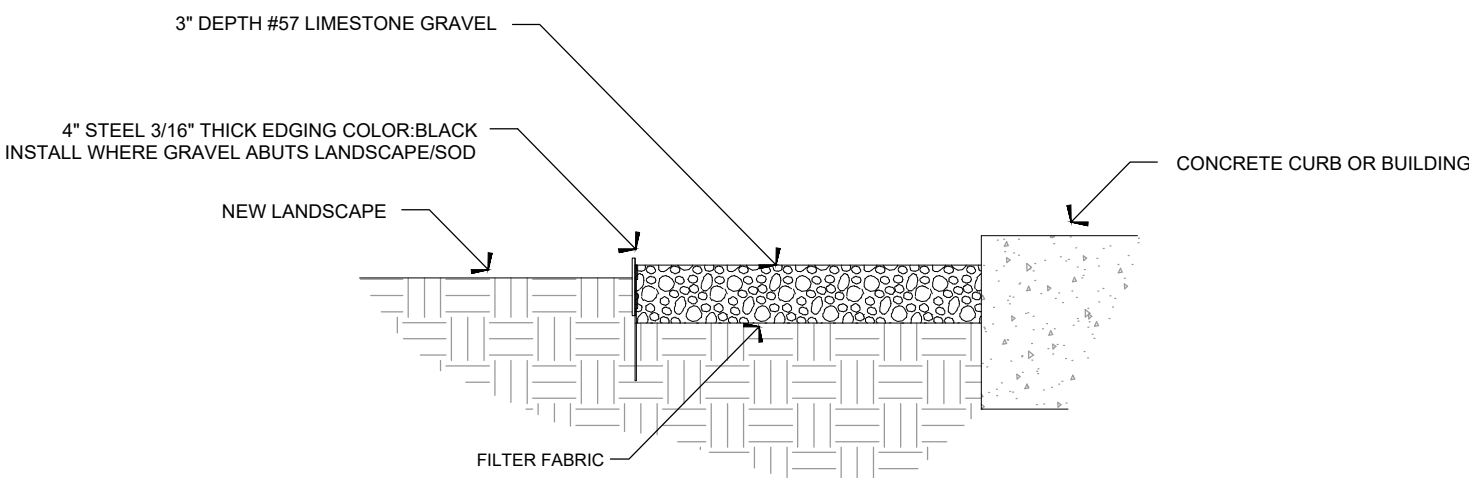



2 GRAVEL MULCH WITH STEEL EDGING

LS-1 N.T.S.

PLANT SCHEDULE

SYMBOL	CODE	QTY	BOTANICAL / COMMON NAME	CONT	CAL	SIZE	
EVERGREEN TREES							
	IE	17	Ilex x attenuata 'Eagleston' / Eagleston Holly	Gallon or B&B	2"-Cal.	8' Min. Ht.	
ORNAMENTAL TREES							
	LI	10	Lagerstroemia indica / Multi-Trunk Crape Myrtle	Gallon or B&B	1.5"Cal. per Trunk 3 Trunk Min.	8' Min. Ht.	
SHADE TREES							
	MS	3	Magnolia virginiana / Sweetbay Magnolia	Gallon or B&B	2.50" Cal.	12' Min. Ht.	
	QN	3	Quercus nuttallii / Nuttall Oak	Gallon or B&B	2.50" Cal.	12' Min. Ht.	
	UB	6	Ulmus parvifolia 'UPMTF' / Bosque® Lacebark Elm	Gallon or B&B	2.50" Cal.	12' Min. Ht.	
SYMBOL	CODE	QTY	BOTANICAL / COMMON NAME	CONT	SIZE		
SHRUBS							
	IB	165	Ilex cornuta 'Burfordii Nana' / Dwarf Burford Holly	7-Gal.	2' ht. at the time of planting		
	JP	52	Juniperus chinensis 'Parsonii' / Parsoni Juniper	3-Gal.			
	RA	90	Rhamnus indica 'Alba' / White Indian Hawthorn	3-Gal.	18"ht. 18"spd.		
	RF	79	Rhododendron obtusum 'Fashion' / Fashion Azalea	3-Gal.	18"ht. 18"spd.		
SYMBOL	CODE	QTY	BOTANICAL / COMMON NAME	CONT	REMARKS		SPACING
GROUND COVERS							
	SEED	2,144 sf	Cynodon dactylon / Bermuda Grass	SF	Hydroseeding		
	SOD	14,850 sf	Cynodon dactylon / Bermuda Grass	Squares or Mini Rolls	Class 'A'		
	GRAVEL	2,292 sf	Mulch Area / Gravel Mulch	#57 Limestone	3" Deep w/Filter Fabric		
	MULCH	5,546 sf	Mulch Area / Hardwood Mulch	Hardwood Mulch	4" Depth		

LINFIELD, HUNTER & JUNIUS, INC.
PROFESSIONAL ENGINEERS,
ARCHITECTS AND SURVEYORS
3608 18th Street, Suite 200
Metairie, Louisiana 70002

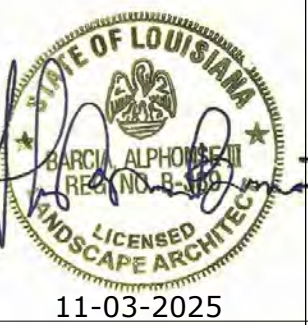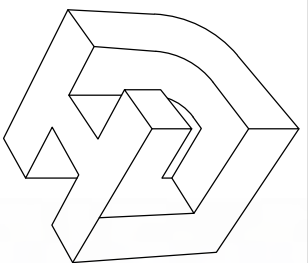

REV. NO.	DATE

APARTMENTS 3800 TEXAS DR.
NEW ORLEANS, LA (ORLEANS PARISH)

LANDSCAPE PLANTING PLAN

SHEET TITLE:

DRAWN BY:

LHJ

CHECKED BY:

LHJ

APPROVED BY:

LHJ

PROJ. NO. 23-104

DATE: 11-03-2025

SHEET NO.

LS-1

OF SHEETS

1.1 GENERAL

A. Submittals: In addition to product certificates, submit the following where applicable:

1. Certification of grass seed/sod from seed/sod vendor for each seed mixture, or for sod.
2. List of plant suppliers and anticipated delivery dates.
3. Provide sample or product data of planting mix, top soil, fertilizers, pre-emergent and mulch or any other amendment required for project.

B. Quality Assurance: Provide trees, shrubs, ground covers, and plants of quality, size, genus,

requirements may be rejected.

C. Special Warranty: Warrant trees, shrubs and ground covers for a period of one year after

Contractor's control.

1. Remove and replace any unhealthy and dead trees and shrubs within the warranty period.

D. Maintain and establish lawns by watering, fertilizing, weeding, mowing, trimming,

following:

1. Sodded Lawns: 30 days after date of Substantial Completion.

1.2 PRODUCTS

A. Trees and Shrubs: Well-shaped, fully branched, healthy, vigorous nursery-grown stock of

ANSI Z60.1.

1. Provide balled and burlapped trees and shrubs (as per plan), or
2. Provide container grown trees and shrubs (as per plan).

B. Ground Covers and Plants: Established and well rooted in removable containers or integral

ANSI Z60.1 for the pot size indicated.

C. Sod: Certified turfgrass sod complying with ASPA specifications for machine-cut thickness,

and capable of vigorous growth and development when planted.

1. Species: Provide sod grass species and varieties, proportions by weight, and minimum per plans.

D. Planting mix: ASTM D 5268, pH range of 5.5 to 7, 4 percent organic material minimum, free

to plant growth.

1. Planting mix: Equal parts of sharp sand, peat moss and composted bark.

E. Lime: ASTM C 602, Class T, agricultural limestone. Add 1,000 - 2,000 lbs/acre as required according to soil sample.

F. Peat Humus: Finely divided or granular texture, with a pH range of 6 to 7.5, composed of

G. Sawdust or Ground-Bark Humus: Decomposed, nitrogen-treated, of uniform texture, free of chips, stones, sticks, soil, or toxic materials.

H. Bonemeal: Commercial, raw, finely ground; minimum of 4 percent nitrogen and 20 percent phosphoric acid. Regulate Ph as needed via soil sample.

I. Superphosphate: Commercial, phosphate mixture, soluble; minimum of 20 percent available phosphoric acid. Regulate Ph as needed via soil sample.

J. Lawn fertilizer: Once lawn is established, apply 1-1-1 commercial-grade quick release fertilizer. Apply according to manufacturer's recommendations.

K. Planting bed fertilizer: Osmacote classic 13-13-13 8 to 9 month longevity or Siera Tabs at planting. Apply in accordance to manufacturer's specifications.

- L. Pre-Emergent Herbicide: FreeHand, Barricade G, Pendulum 2G, or Sanpsot. Apply according to manufacturer's recommendations for pre and post planting.

M. Organic Mulch: Organic mulch, free from deleterious materials and suitable as a top

shredded hardwood.

N. Mineral Mulch: Hard, durable riverbed gravel or crushed stone, washed free of loam, sand, clay, and other foreign substances.

1. Size Range: 1-1/2 inches (38 mm) maximum, 3/4 inch (19 mm) minimum.

O. Steel Edging: ASTM A 569 (ASTM A 569M), standard painted comercial grade steel edging

install edging to be sanded and painted to match factory finish.

1. Edging Size: 3/16 inch (4.8 mm) wide by 4 inches (102 mm) deep.

1.3 EXECUTION

A. Planting Mix Preparation: Before mixing, clean topsoil of roots, plants, sods, stones, clay lumps, and other extraneous materials harmful to plant growth. Mix soil amendments and fertilizers with topsoil at rates indicated.

B. Lawn Planting Preparation (Disturbed): Loosen subgrade to a minimum depth of 6 inches (150 mm). Remove stones larger than 1-1/2 inches (38 mm) in any dimension and sticks, roots, rubbish, and other extraneous materials.

1. Incorporate topsoil soil mixture into existing soil to depth required to meet thickness, grades, and elevations shown, after light rolling and natural settlement. Do not spread if planting soil or subgrade is frozen.
2. Till surface soil to a depth of at least 6 inches (150 mm). Apply soil amendments and initial fertilizers and mix thoroughly into top 6 inches (150 mm) of soil. Trim high areas and fill in depressions. Till soil to a homogenous mixture of fine texture.

C. Lawn Planting Preparation (Undisturbed): Where lawns are to be planted in areas unaltered or undisturbed by excavating, grading, or surface soil stripping operations, remove and dispose of existing grass, vegetation, and turf.

1. Till surface soil to a depth of at least 6 inches (150 mm). Apply soil amendments and initial fertilizers and mix thoroughly into top 6 inches (150 mm) of soil. Trim high areas and fill in depressions. Till soil to a homogenous mixture of fine texture.

D. Moisten prepared lawn areas before planting when soil is dry and allow surface to dry before planting.

E. Ground Cover and Plant Bed Preparation: Loosen subgrade of planting bed areas to a minimum depth of 6 inches (150 mm). Remove stones larger than 1-1/2 inches (38 mm) in any dimension and sticks, roots, rubbish, and other extraneous materials.

1. Spread planting soil mixture to depth required to meet thickness, grades, and elevations shown, after light rolling and natural settlement. Place approximately 1/2 the thickness of planting soil mixture required. Work into top of loosened subgrade to create a transition layer and then place remainder of planting soil mixture.

F. Excavation for Trees and Shrubs: Excavate pits with vertical sides and with bottom of excavation slightly raised at center to assist drainage. Excavate approximately 1-1/2 times as wide as ball diameter and deep enough to allow placing of root ball on a setting layer of planting soil. Loosen hard subsoil in bottom of excavation.

G. Planting Trees and Shrubs: Set stock plumb and in center of pit or trench with top of ball raised above adjacent finish grades.

1. Place a setting layer of compacted planting soil.
2. Cut burlap and wire baskets from tops of balls and pull partially from sides, but do not remove from under balls. Do not use planting stock if ball is cracked or broken before or during planting operation.
3. Place backfill around ball in layers, tamping to settle backfill and eliminate voids and air pockets.
4. Dish and tamp top of backfill to form a 3-inch- (75-mm-) high mound around the rim of the pit. Do not cover top of root ball with backfill.

H. Tree and Shrub Pruning: Prune, thin, and shape trees and shrubs according to standard horticultural practice. Prune trees to retain required height and spread. Do not cut tree leaders; remove only injured or dead branches from flowering trees. Prune shrubs to retain natural character. Shrub sizes indicated are size after pruning.

I. Planting Ground Cover and Plants: Plant spacing according to plan, unless otherwise indicated. Dig holes large enough to allow spreading of roots, and backfill with planting soil. Work soil around roots to eliminate air pockets and leave a slight saucer indentation around plants to hold water. Water thoroughly after planting, taking care not to cover plant crowns with wet soil.

J. Planting Bed Fertilizer: Install per manufactures recommendations.

K. Pre-Emergent Herbicide: Install per manufactures recommendations.

L. Mulching: Completely cover area to be mulched. Apply mulch and finish level with adjacent finish grades. Do not place mulch against trunks or stems.

1. Mulch Type and Thickness: Pine Bark Mulch, 3 inch depth

M. Sodding Lawns: Lay sod to form a solid mass with tightly fitted joints within 24 hours of stripping. Butt ends and sides of sod; do not stretch or overlap. Stagger sod strips or pads to offset joints in adjacent courses. Avoid damage to subgrade or sod during installation. Tamp and roll lightly to ensure contact with subgrade, eliminate air pockets, and form a smooth surface. Work sifted soil or fine sand into minor cracks between pieces of sod; remove excess to avoid smothering sod and adjacent grass.

1. Anchor sod on slopes exceeding 1:6 with wood pegs spaced as recommended by sod manufacturer.
2. Saturate sod with fine water spray within 2 hours of planting. During first week, water daily or more frequently as necessary to maintain moist soil to a minimum depth of 1-1/2 inches (38 mm) below the sod.

N. Edgings: Install edgings where indicated and anchor with stakes driven below top elevation of edging according to manufacturer's recommendations.


O. Disposal: Remove surplus soil and waste material, including excess subsoil, unsuitable soil, trash, and debris, and legally dispose of it off the Owner's property.

END OF SECTION 02900



ALPHONSE BARCIA III
LANDSCAPE ARCHITECT LLC.



562 CLAYTON COURT
SLIDELL, LOUISIANA 70461
BARCIADESIGNS@GMAIL.COM
(985) 960-0429

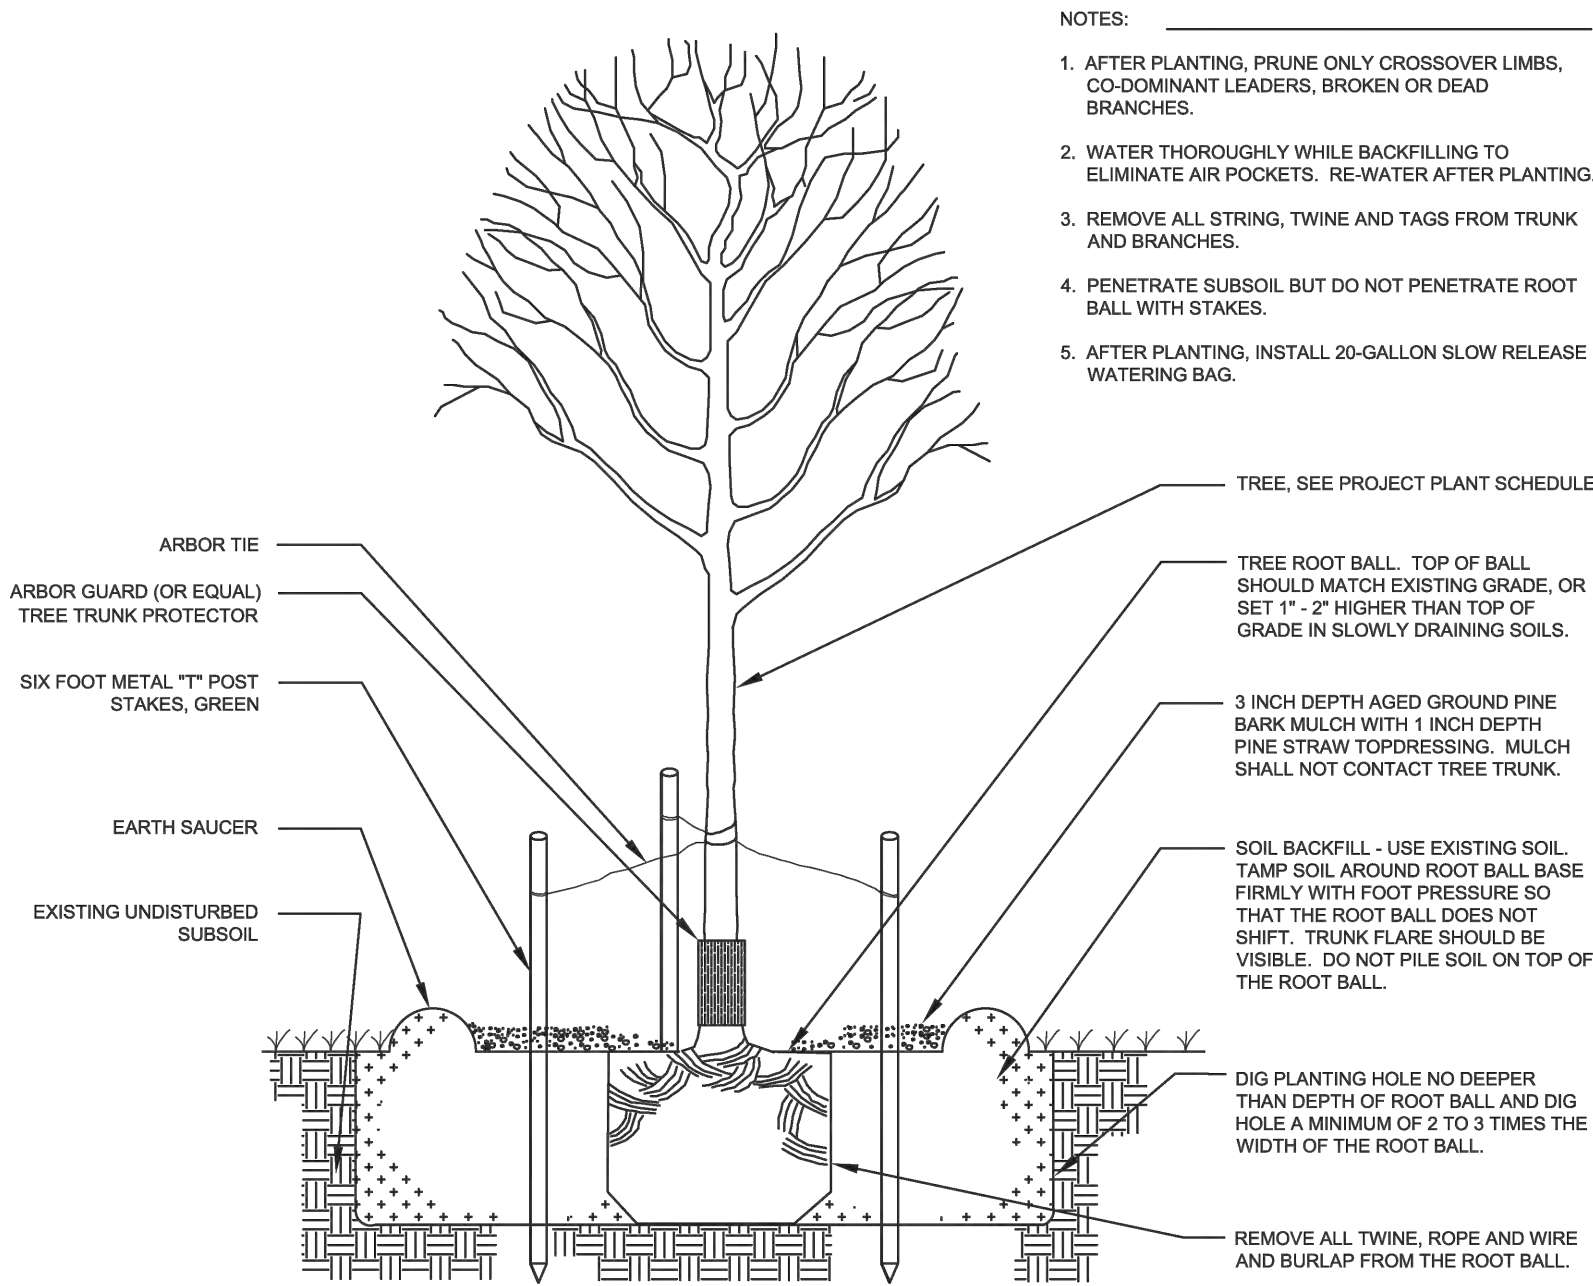

TREE PLANTING DETAIL

N. T. S.

LINFIELD, HUNTER & JUNIUS, INC.
PROFESSIONAL ENGINEERS,
ARCHITECTS AND SURVEYORS
3608 18th Street, Suite 200
Metairie, Louisiana 70002

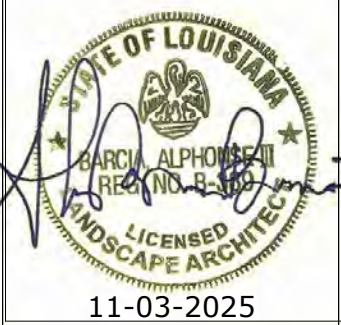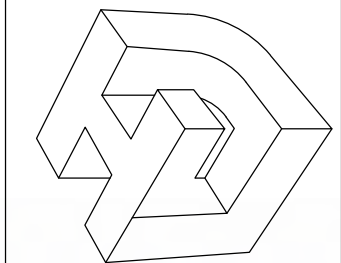


REV. NO.	DATE

APARTMENTS 3800 TEXAS DR. NEW ORLEANS, LA (ORLEANS PARISH)		LANDSCAPE SPECS AND DETAILS	
SHEET TITLE:	APPROVED BY:	CHECKED BY:	DRAWN BY:
	LHJ	LHJ	LHJ


PROJ. NO.	23-104
DATE:	11-03-2025
SHEET NO.	

LS-2


OF SHEETS

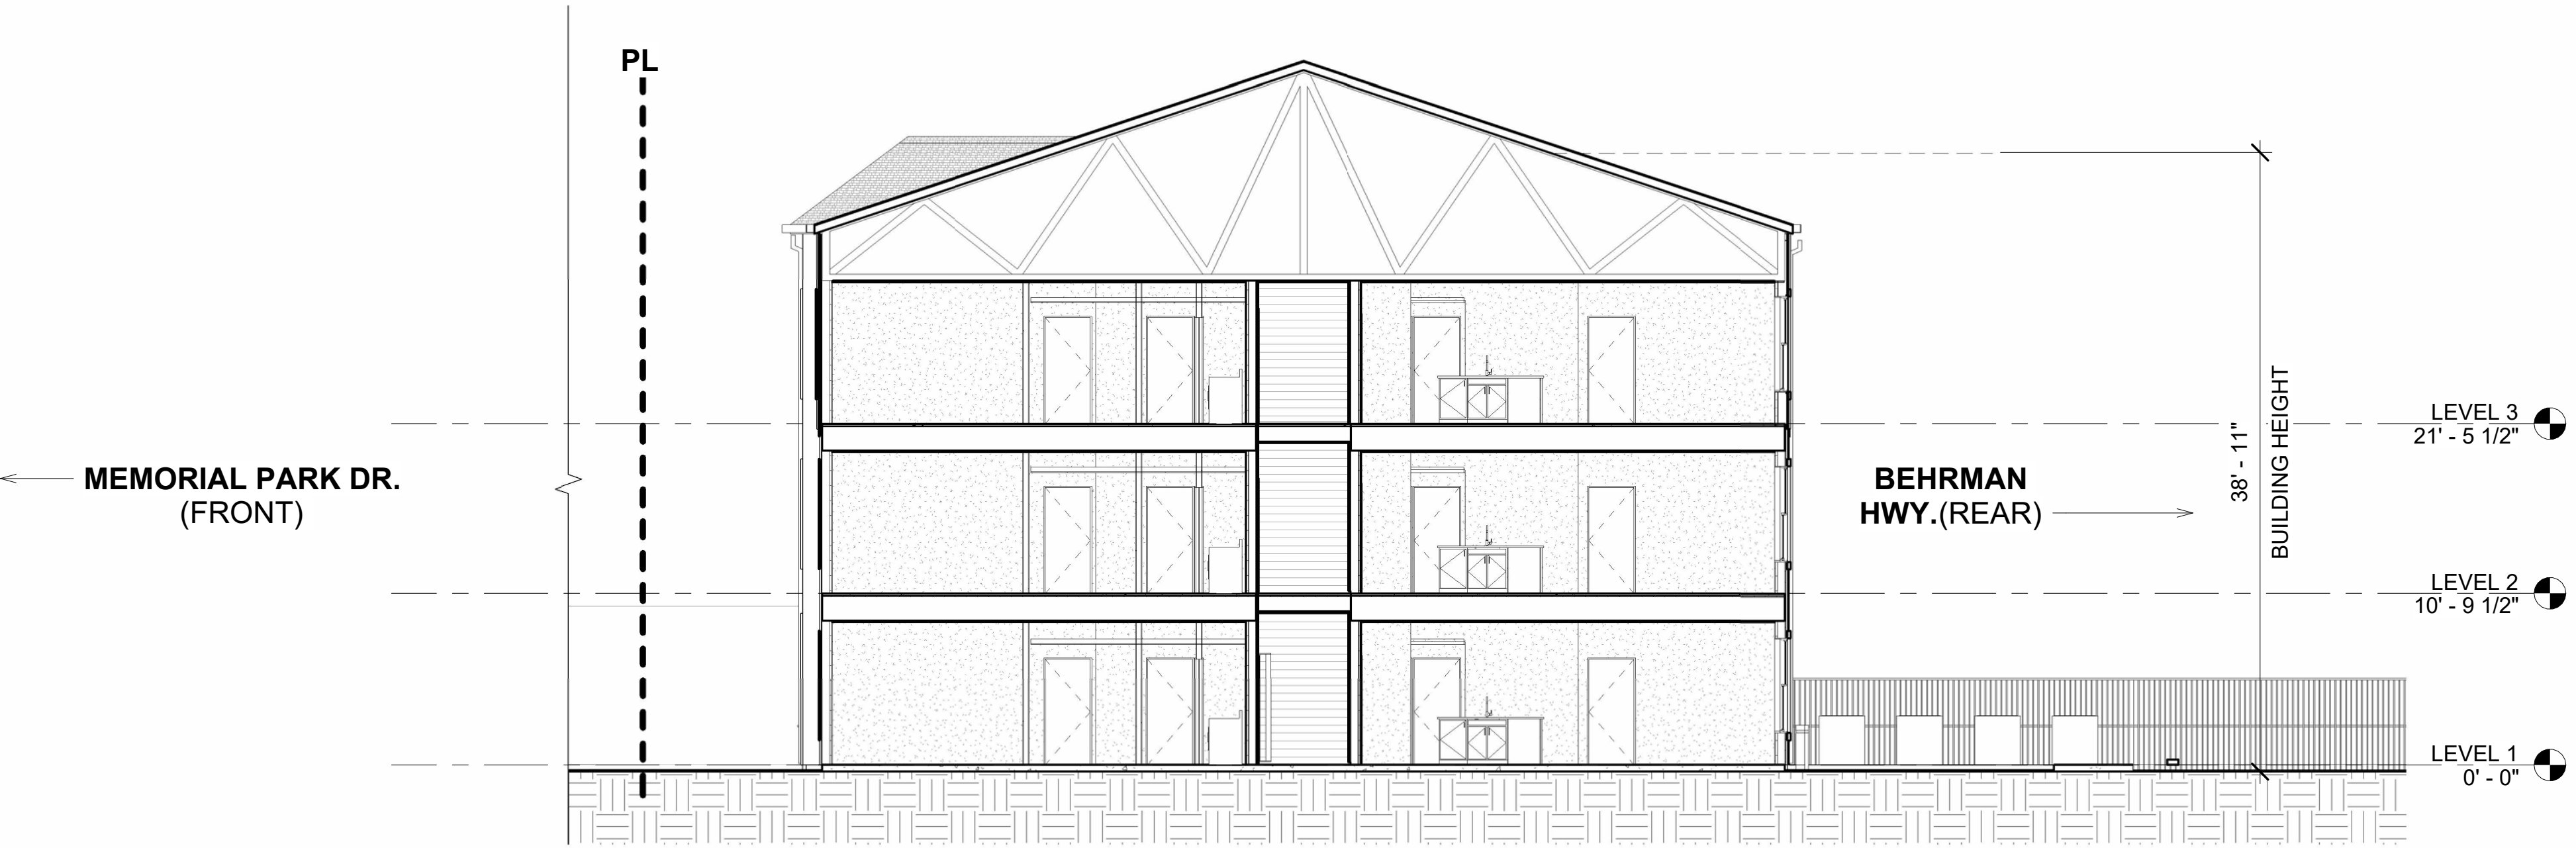

① SITE SECTION 01
1/8" = 1'-0"

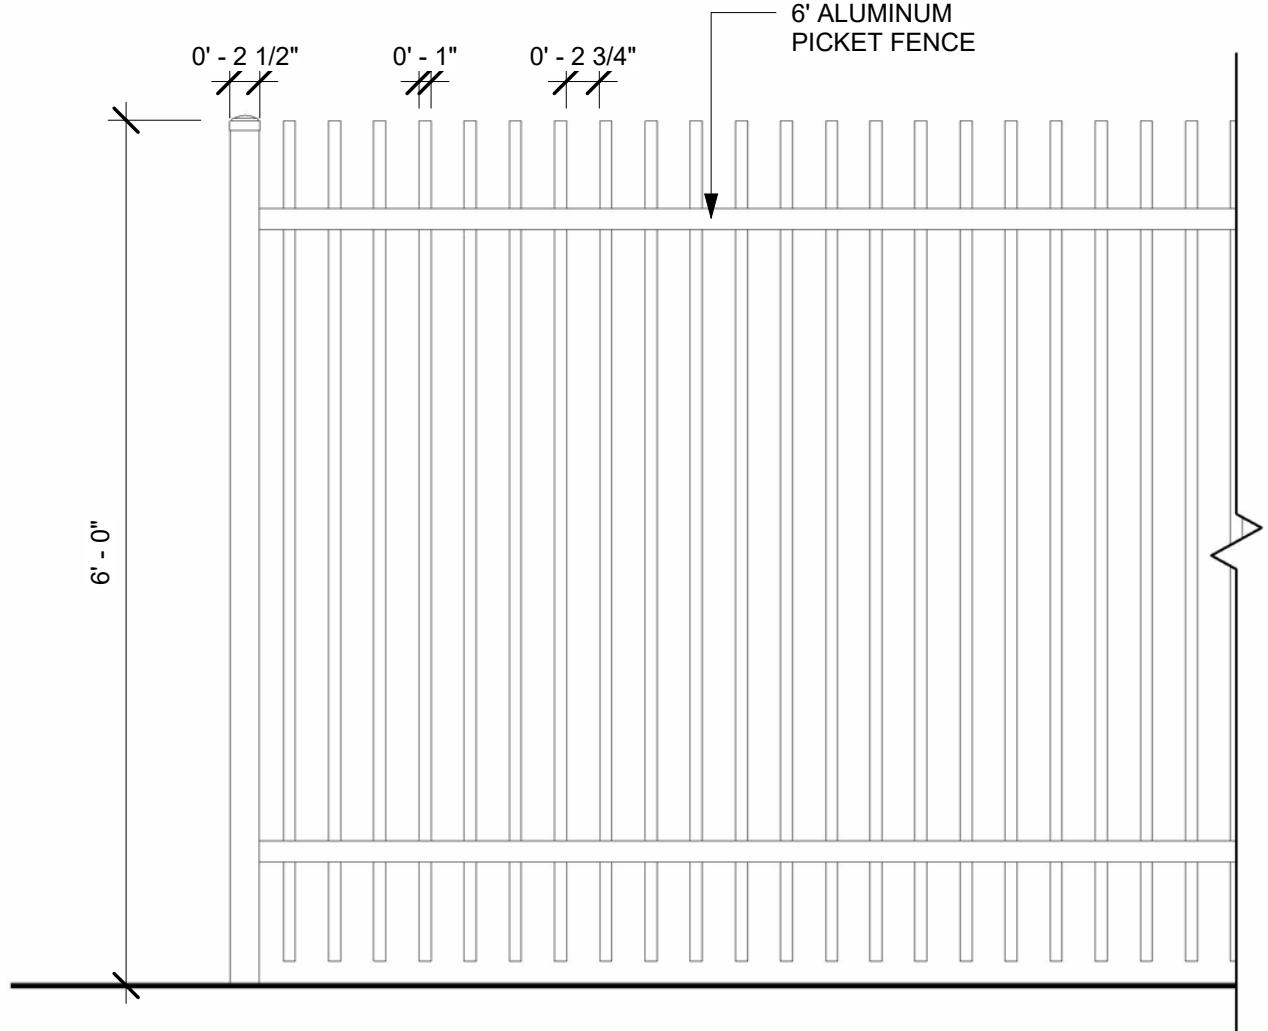

② FENCE - ELEVATION, TYP.
3/4" = 1'-0"

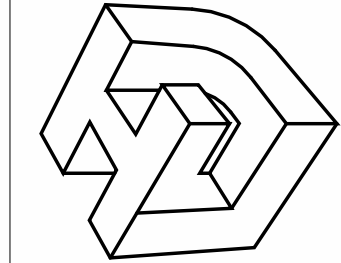

LINFIELD, HUNTER & JUNIUS, INC.
PROFESSIONAL ENGINEERS,
ARCHITECTS AND SURVEYORS
3608 18th Street, Suite 200
Metairie, Louisiana 70002

© 2025 by Linfield, Hunter & Junius, Inc.

SEAL

REV NO.	DATE:

APARTMENTS | 3800 TEXAS DRIVE
NEW APARTMENTS

SHEET TITLE
SITE SECTION & FENCE ELEVATION

DRAWN BY: Author
CHECKED BY: Checker
APPROVED BY: Approver

PROJ. NO. 23-104
DATE: 11.07.2025
SHEET NO.

A052

OF SHEETS

1" = 10'-0"
LEVEL 1 - OVERALL FLOOR PLAN



TEXAS DR. (SIDE)

MEMORIAL PARK DR. (FRONT)

BEHRMAN PL. (SIDE)

BEHRMAN HWY. (REAR)

OWNER REVIEW SET - NOT FOR CONSTRUCTION

APARTMENTS | 3800 TEXAS DRIVE
NEW APARTMENTS

SHEET TITLE
FIRST FLOOR PLAN

DRAWN BY:
Author

CHECKED BY:
Checker



APPROVED BY:
Approver

REV NO. DATE:

SEAL


LINFIELD, HUNTER & JUNIUS, INC.
PROFESSIONAL ENGINEERS,
ARCHITECTS AND SURVEYORS
3608 18th Street, Suite 200
Metairie, Louisiana 70002

© 2025 by Linfield, Hunter & Junius, Inc.

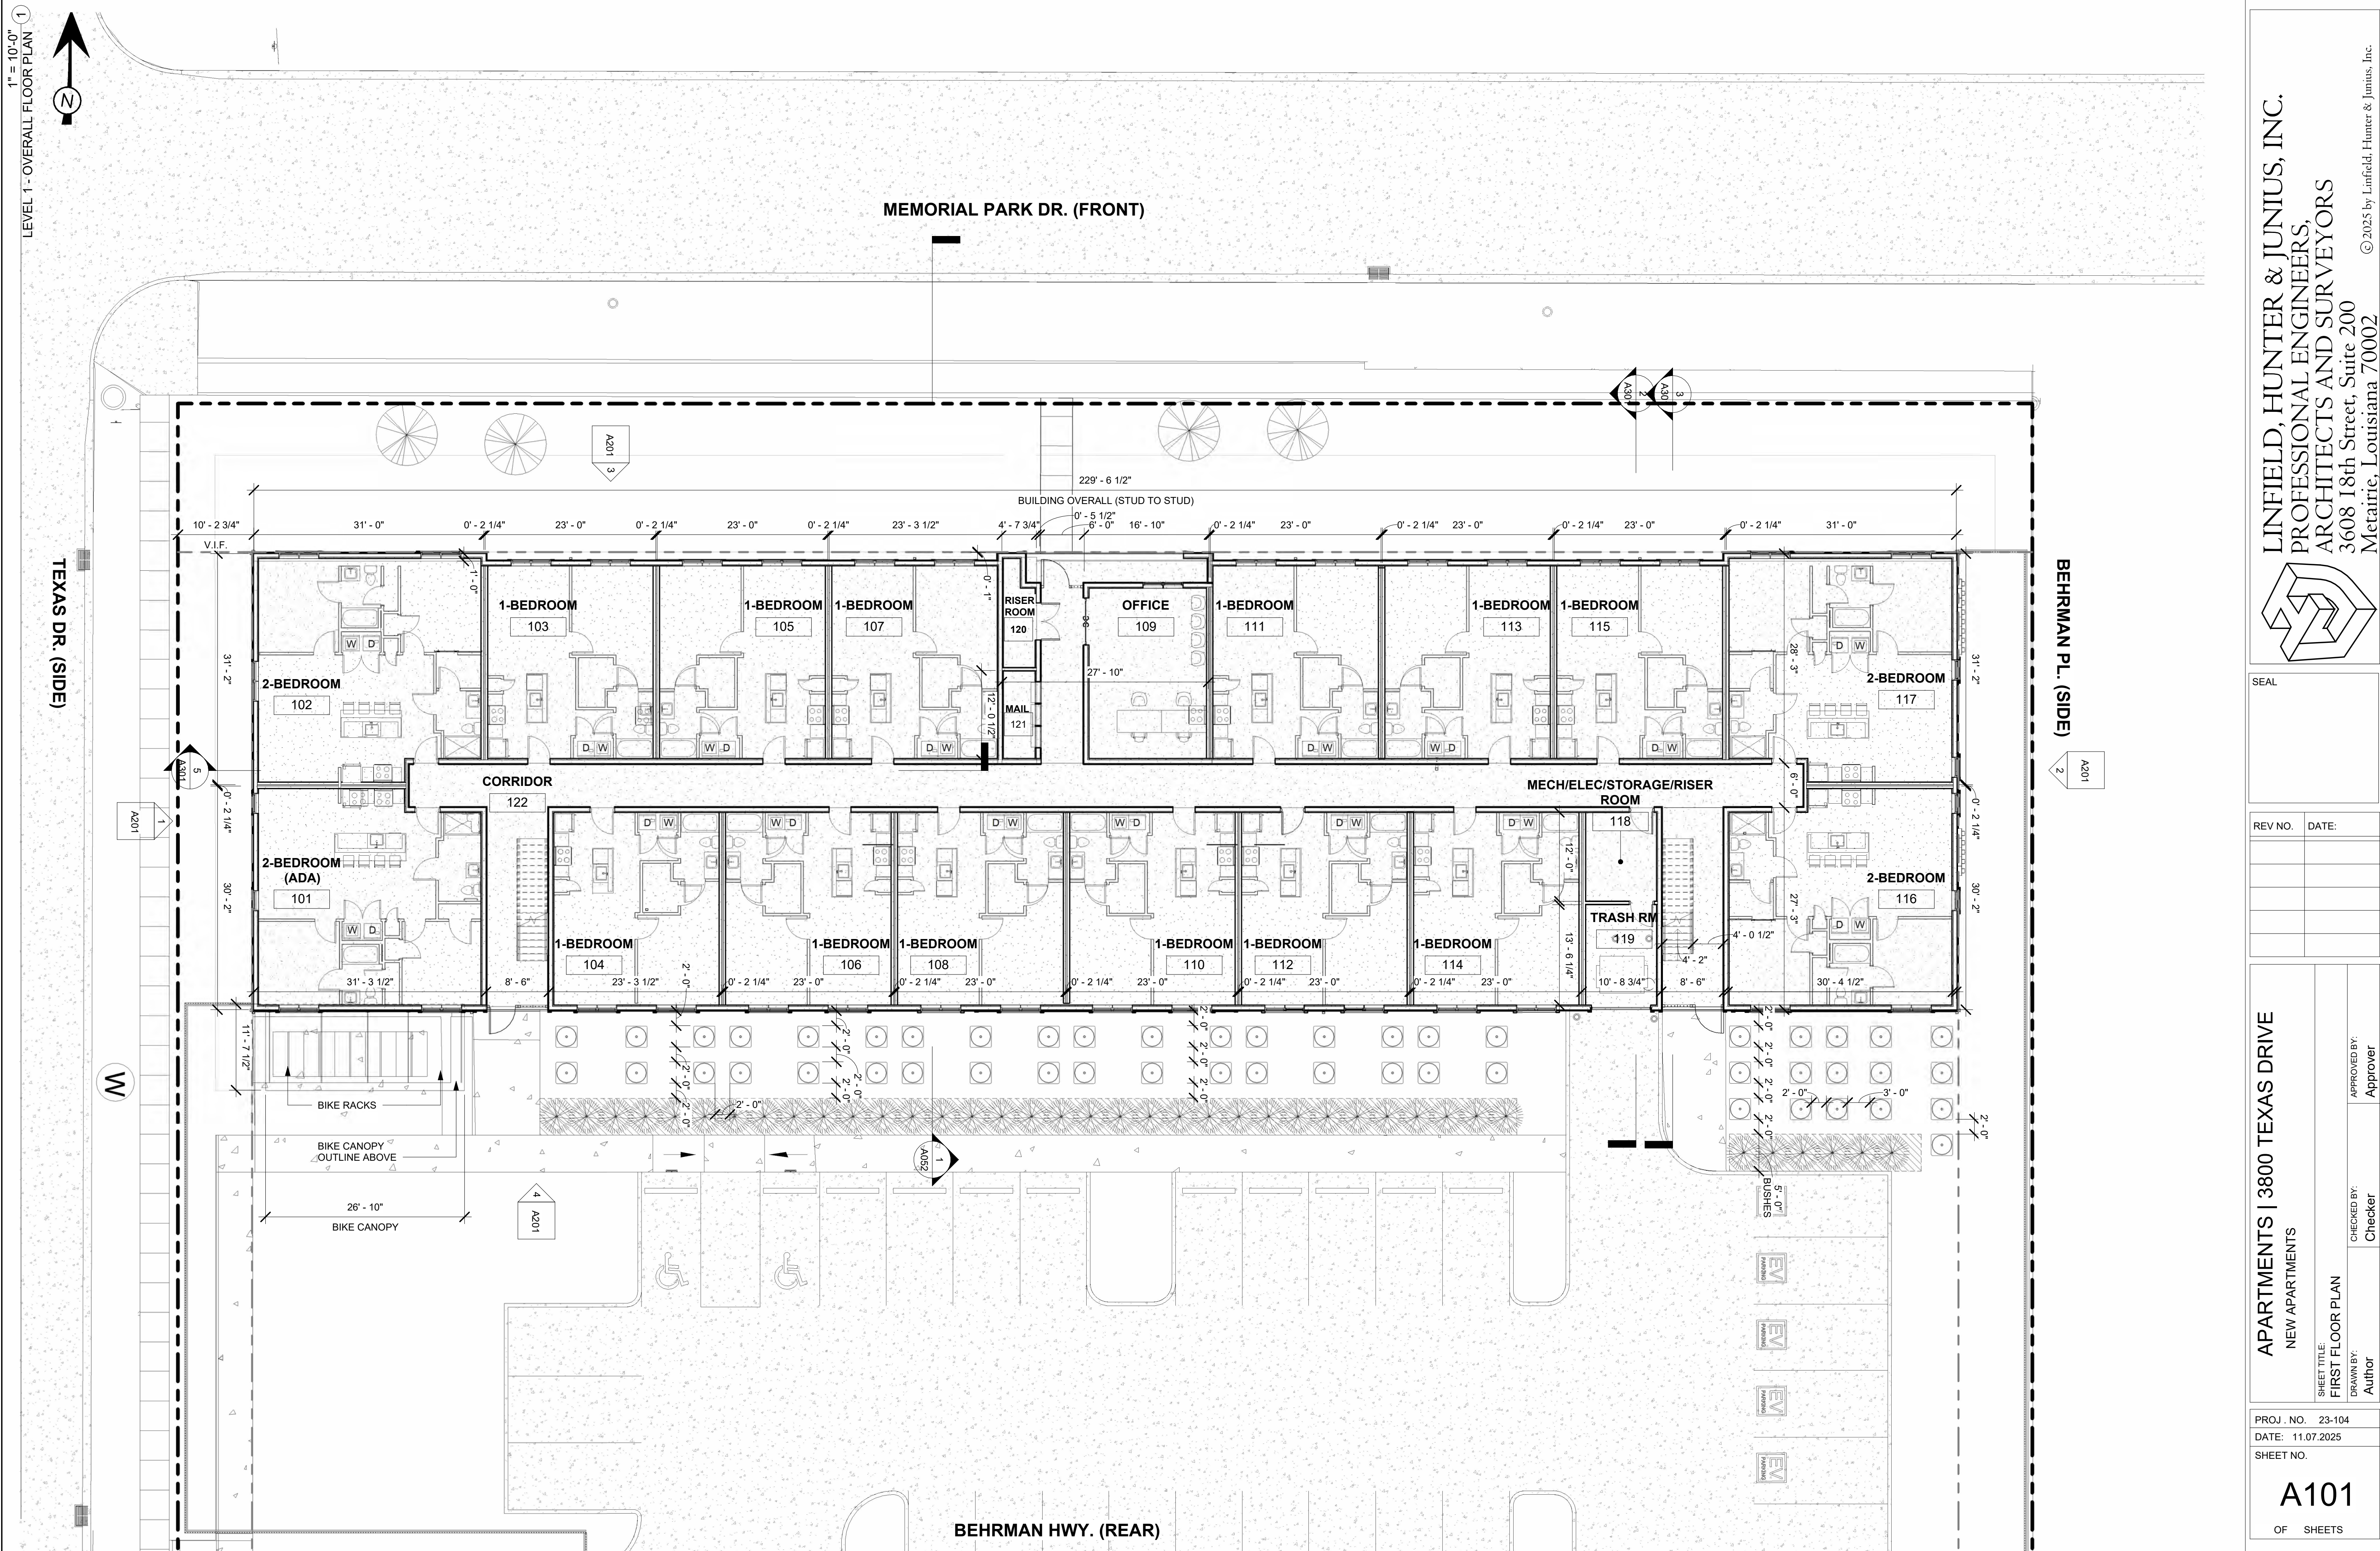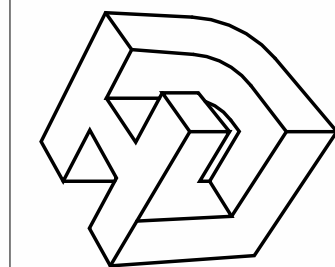




SEAL

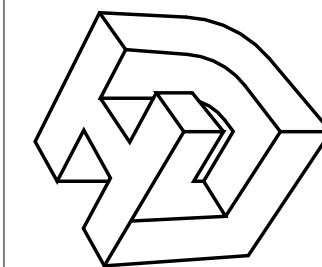


LINFIELD, HUNTER & JUNIUS, INC.,
PROFESSIONAL ENGINEERS,
ARCHITECTS AND SURVEYORS
3608 18th Street, Suite 200
Metairie, Louisiana 70002
©2025 by Linfield, Hunter, & Junius, Inc.

©2025 by Linfield, Hunter & Junius, Inc.




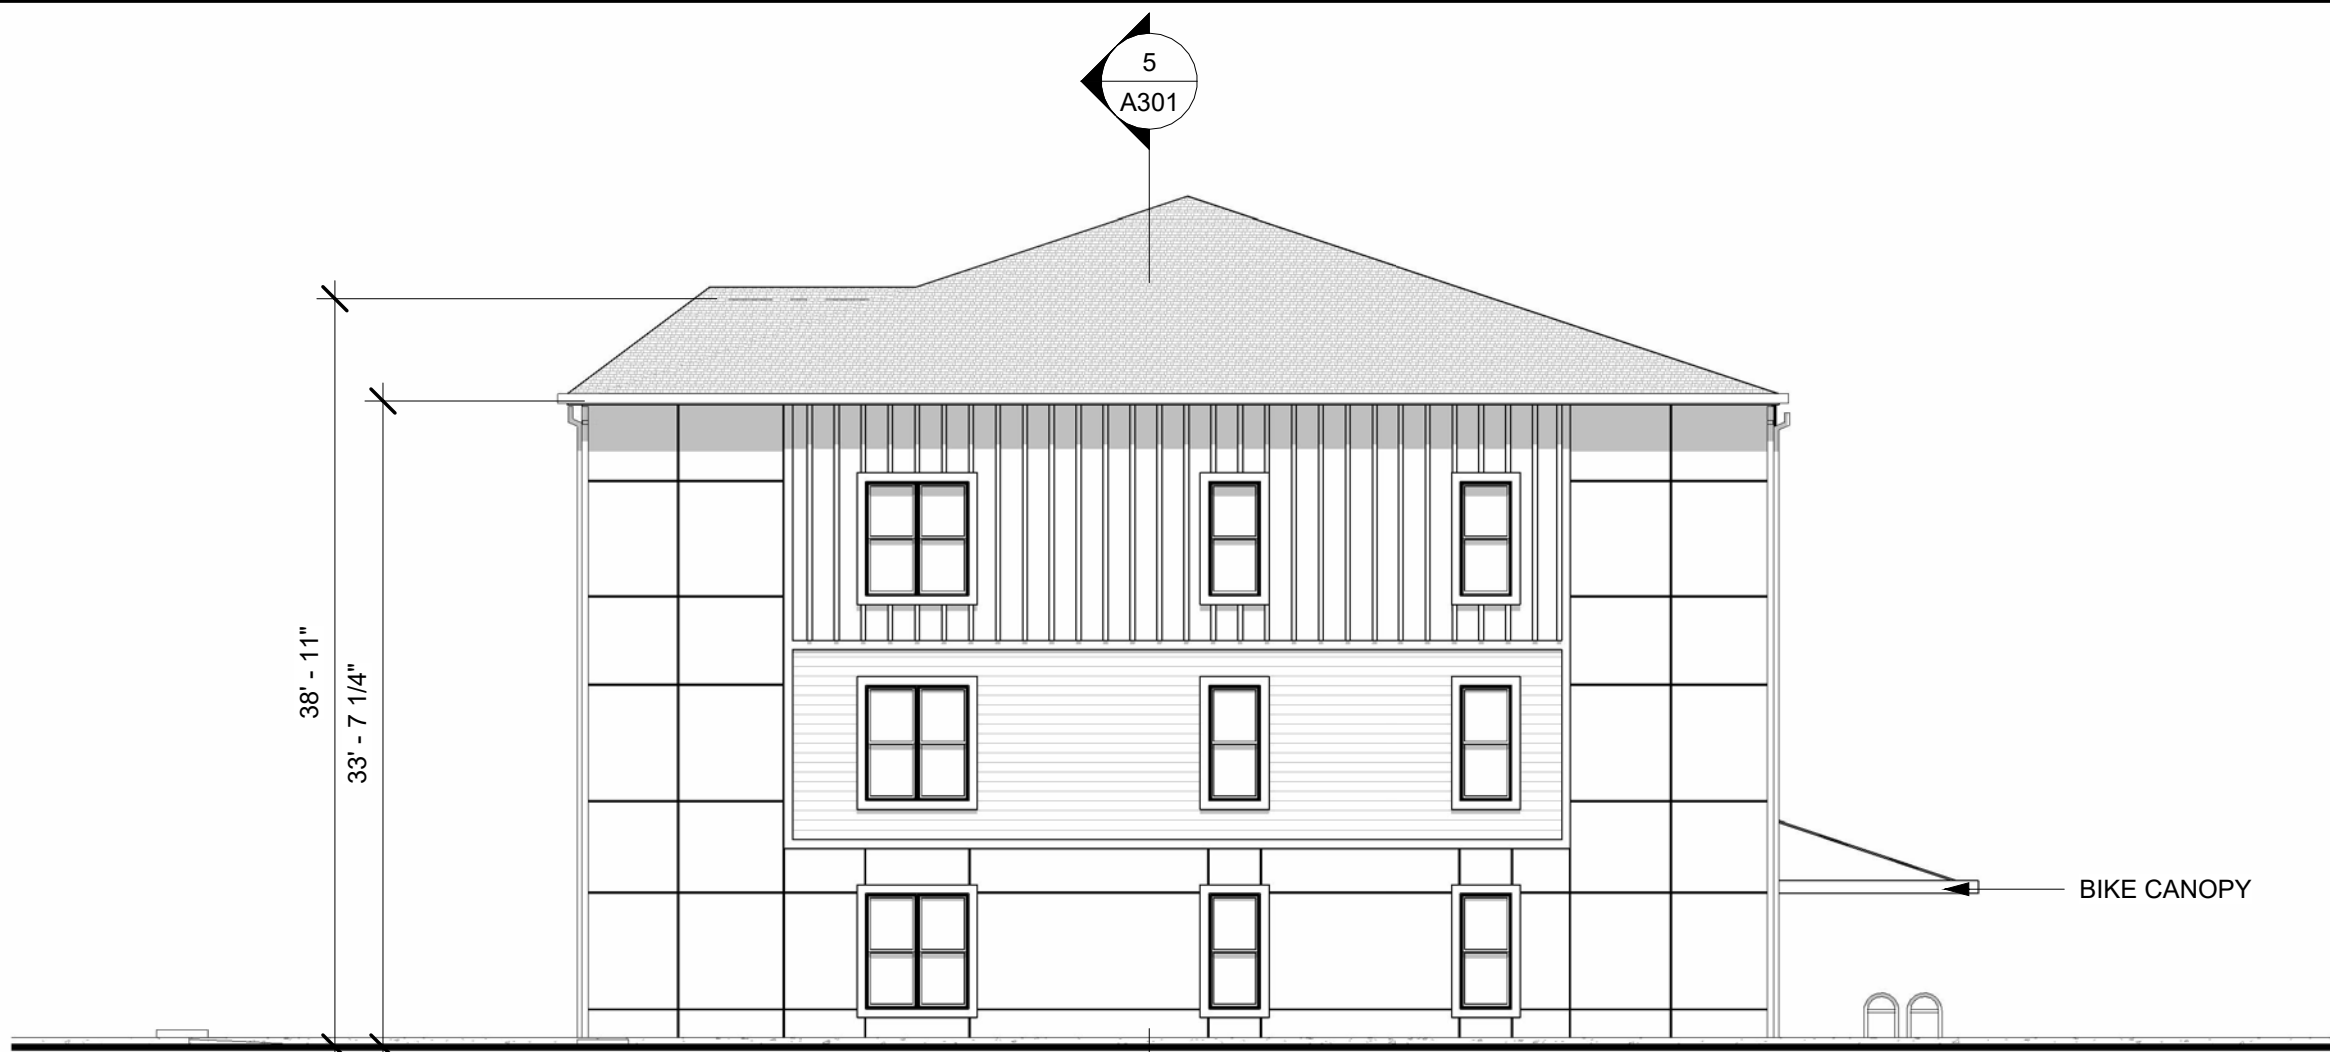


① TEXAS DR. (SIDE)
1" = 10'-0"

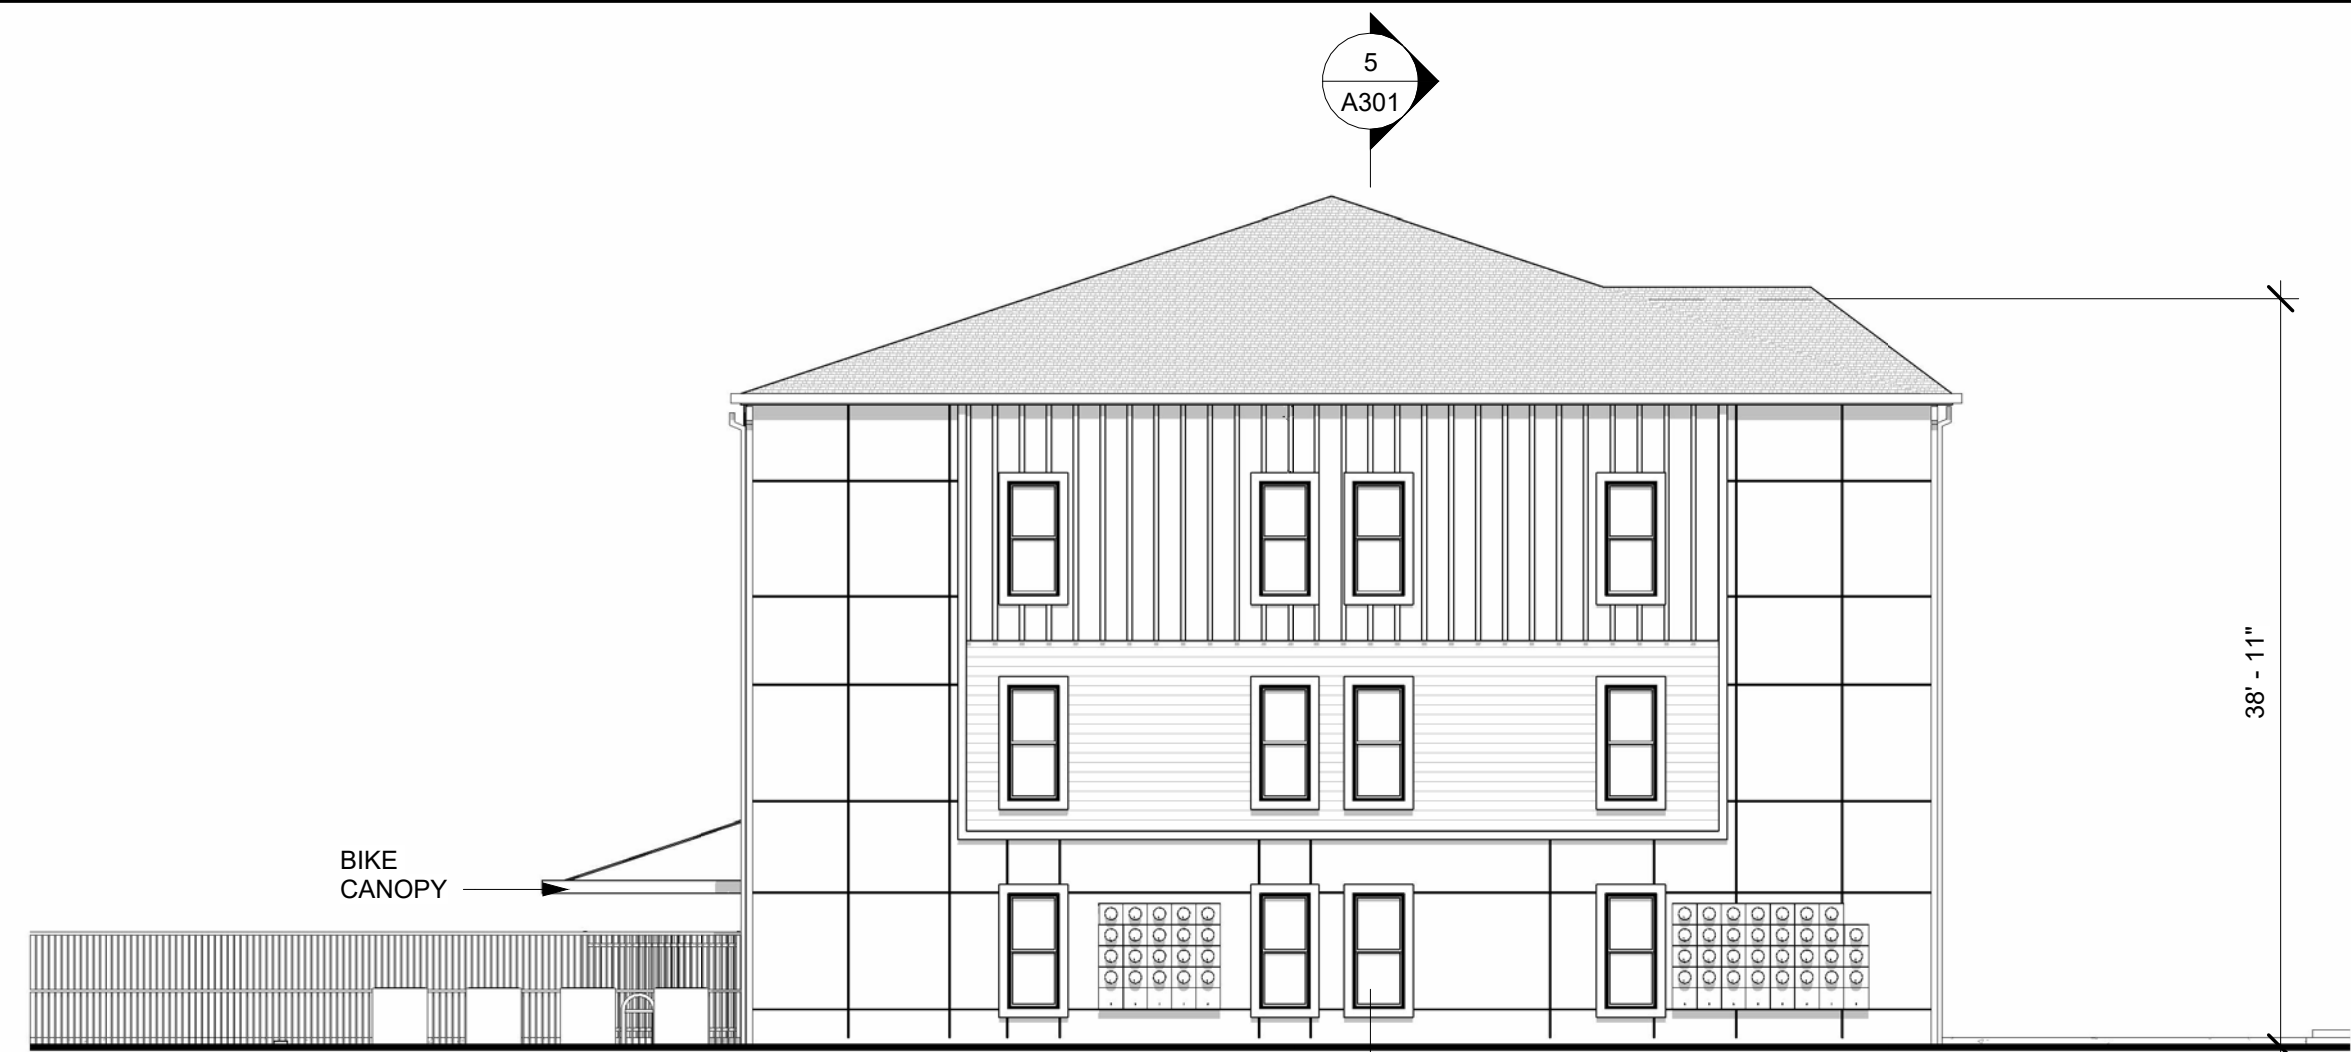

② BEHRMAN PL. (SIDE)
1" = 10'-0"

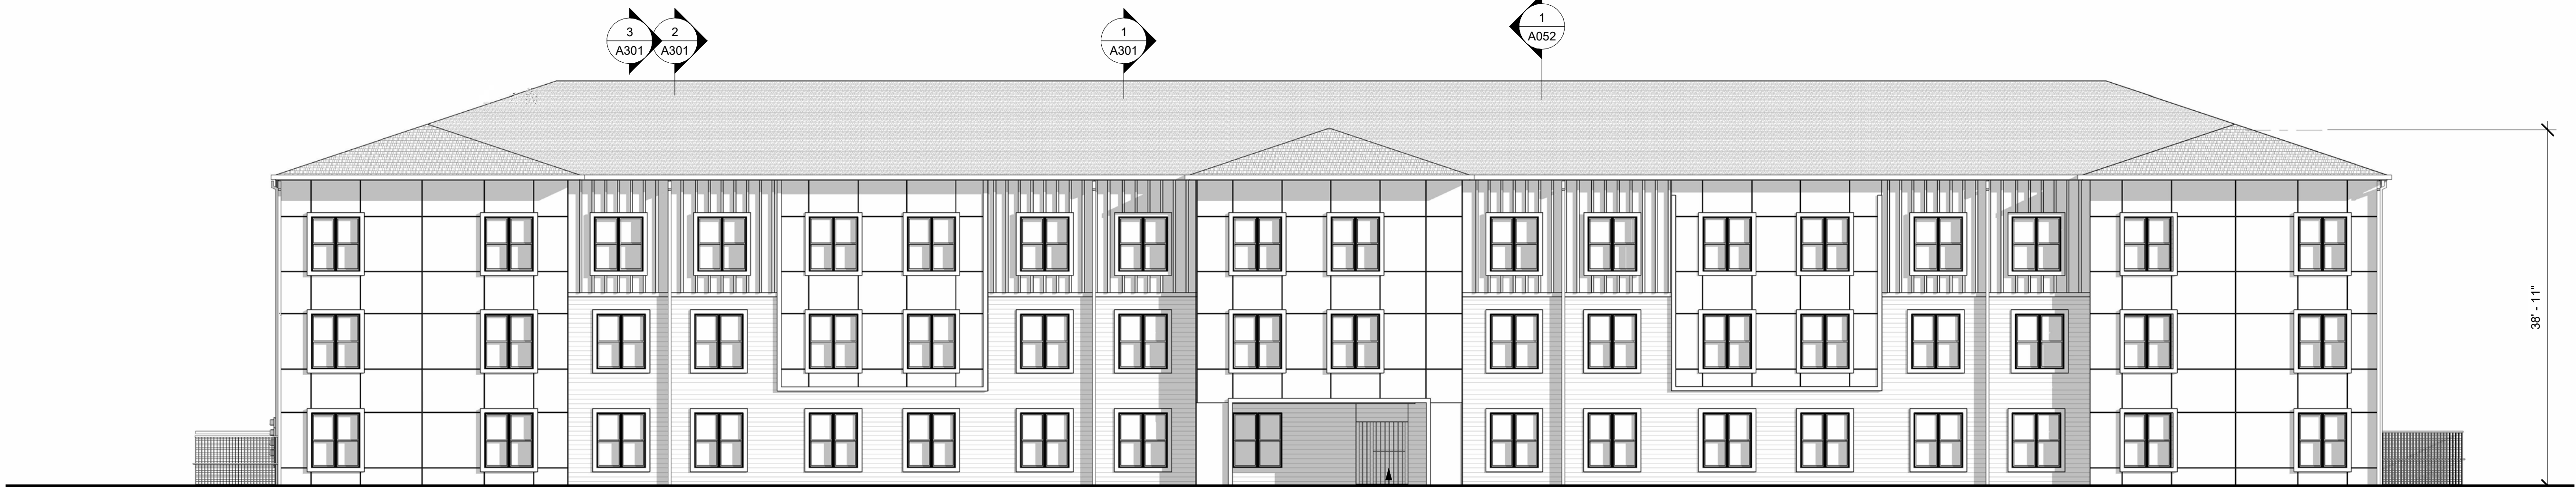


③ MEMORIAL PARK DR. (FRONT)
1" = 10'-0"

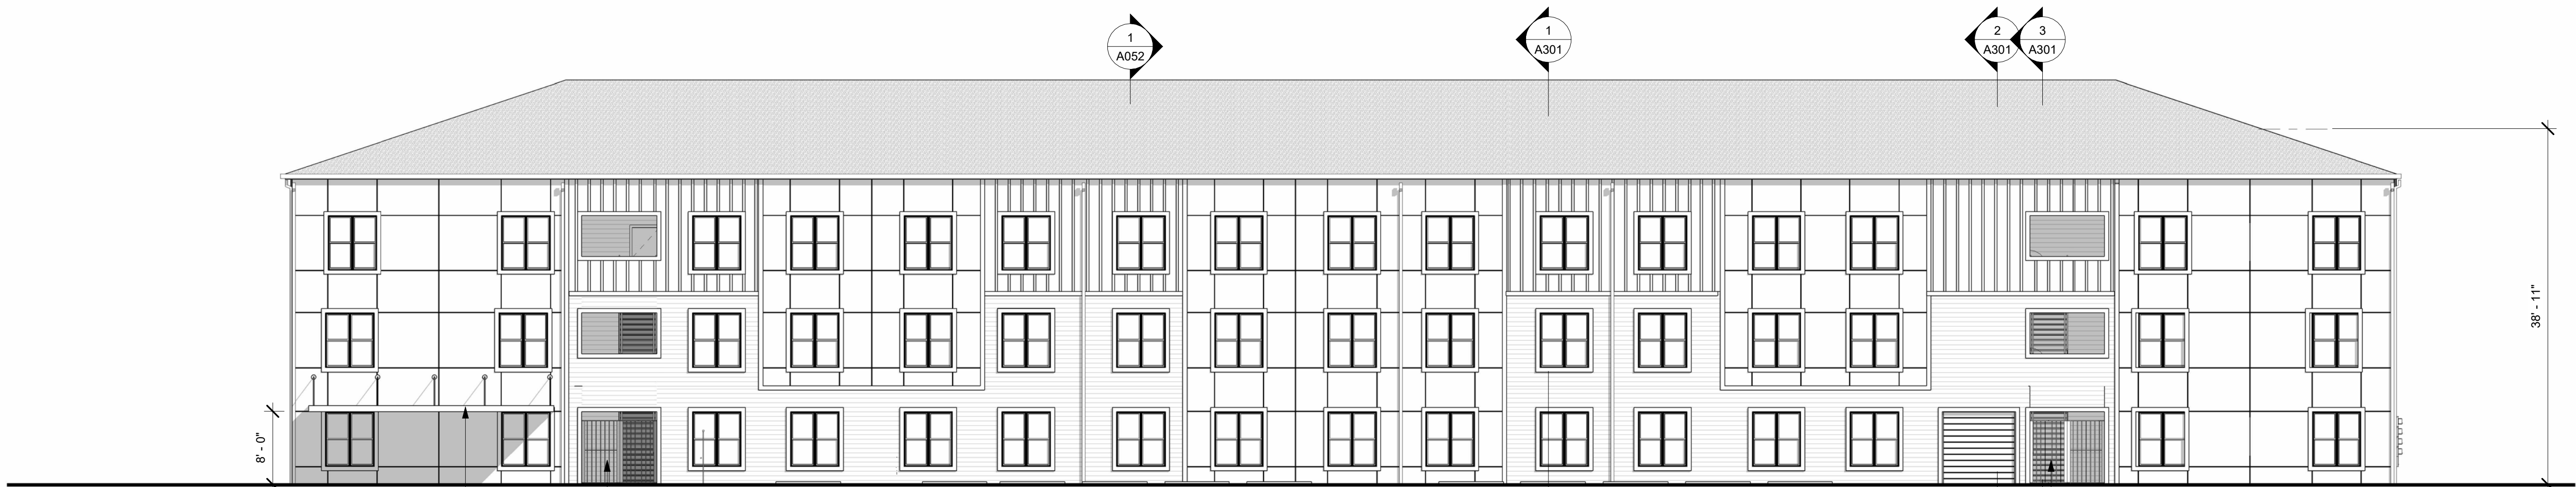

④ BEHRMAN HWY. (REAR)
1" = 10'-0"

LINFIELD, HUNTER & JUNIUS, INC.
PROFESSIONAL ENGINEERS,
ARCHITECTS AND SURVEYORS
3608 18th Street, Suite 200
Metairie, Louisiana 70002

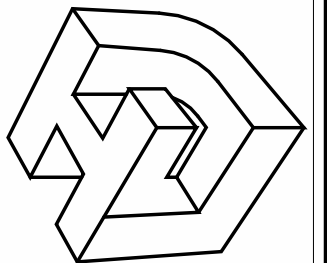

SEAL

REV NO. DATE:

APARTMENTS | 3800 TEXAS DRIVE
NEW APARTMENTS

SHEET TITLE
BUILDING ELEVATIONS

DRAWN BY:
Author

CHECKED BY:
Checker

APPROVED BY:
Approver

PROJ. NO. 23-104

DATE: 11.07.2025

SHEET NO.

A201

OF SHEETS

OWNER REVIEW SET - NOT FOR CONSTRUCTION



8 BERHMAN PL. (SIDE) - RENDER
1" = 10'-0"




7 TEXAS DR. (SIDE) - RENDER
1" = 10'-0"



4 BEHRMAN HWY. (REAR)
1" = 10'-0"



6 MEMORIAL PARK DR. (FRONT)
1" = 10'-0"

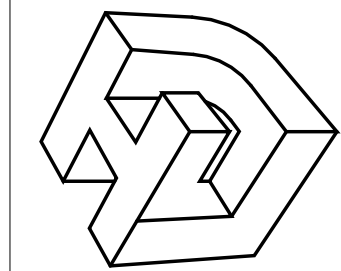

LINFIELD, HUNTER & JUNIUS, INC.
PROFESSIONAL ENGINEERS,
ARCHITECTS AND SURVEYORS
3608 18th Street, Suite 200
Metairie, Louisiana 70002


PRELIMINARY
FOR REVIEW ONLY
NOT FOR CONSTRUCTION
THIS DRAWING IS SUBJECT TO
REVISION, ALTERATION & DELETION

APARTMENTS | 3800 TEXAS DRIVE

PROJ. NO. 23-104
DATE: 11.07.2025
SHEET NO.

A202
OF SHEETS

SHEET TITLE BUILDING ELEVATIONS - COLOR DRAWN BY: Author	CHECKED BY: Checker	APPROVED BY: Approver

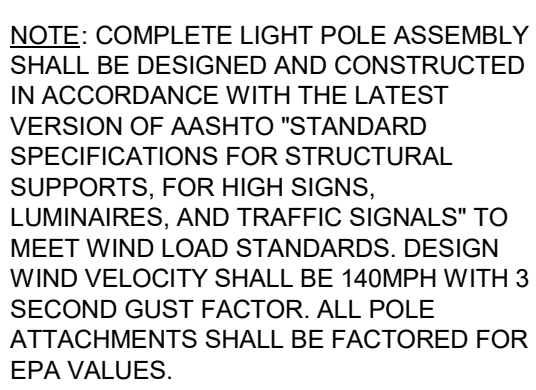

1





Mirada Medium (MRM)

Outdoor LED Area Light

**IP66 IK08**

OVERVIEW

Lumen Package	7,000 - 55,000
Wattage Range	48 - 438
Efficacy Range (LPW)	115 - 162
Weight lbs(kg)	30 (13.6)
Control Options	IMSBT, ALB, ALS, 7-Pin, PCI

QUICK LINKS

[Ordering Guide](#)[Performance](#)[Photometrics](#)[Dimensions](#)

FEATURES & SPECIFICATIONS

Construction

- Rugged die-cast aluminum housing contains factory prewired driver and optical unit. Cast aluminum wiring access door located underneath.
- Designed to mount to square or round poles.
- Fixtures are finished with LSI's DuraGrip® polyester powder coat finishing process. The DuraGrip finish withstands extreme weather changes without cracking or peeling. Other standard LSI finishes available. Consult factory.
- Shipping weight: 37 lbs in carton.

Optical System

- State-of-the-Art one piece silicone optic sheet delivers industry leading optical control with an integrated gasket to provide IP66 rated sealed optical chamber in 1 component.
- Proprietary silicone refractor optics provide exceptional coverage and uniformity in IES Types 2, 3, 4, 5W, FT, FTA, AM, and LC/RC.
- Silicone optical material does not yellow or crack with age and provides a typical light transmittance of 93-95%.
- Zero uplight.
- Available in 5000K, 4000K, and 3000K color temperatures per ANSI C78.377. Also Available in Phosphor Converted Amber with Peak intensity at 610nm.
- Minimum CRI of 70.
- Integral louver (IL) and integral half louver (IH) options available for enhanced backlight control.

Electrical

- High-performance programmable driver features over-voltage, under-voltage, short-circuit and over temperature protection. Custom lumen and wattage packages available.
- 0-10V dimming (10% - 100%) standard.
- Standard Universal Voltage (120-277 Vac) Input 50/60 Hz or optional High Voltage (347-480 Vac).
- L80 Calculated Life: >100k Hours (See Lumen Maintenance chart)
- Total harmonic distortion: <20%
- Operating temperature: -40°C to +50°C (-40°F to +122°F). 42L and 48L lumen packages rated to +40°C. 55L lumen package rate to +35°C.
- Power factor: >.90
- Input power stays constant over life.
- Field replaceable 10kV surge protection device meets a minimum Category C Low operation (per ANSI/IEEE C62.41.2).
- High-efficacy LEDs mounted to metal-core circuit board to maximize heat dissipation
- Components are fully encased in potting material for moisture resistance. Driver complies with FCC standards. Driver and key electronic components can easily be accessed.

Controls

- Optional integral passive infrared Bluetooth™ motion. Fixtures operate independently and can be commissioned via iOS or Android configuration app
- LSI's AirLink™ wireless control system options reduce energy and maintenance

costs while optimizing light quality 24/7. (see controls section for more details).

Installation

- Designed to mount to square or round poles.
- A single fastener secures the hinged door, underneath the housing and provides quick & easy access to the electrical compartment.
- Included terminal block accepts up to 12 ga. wire.
- Utilizes LSI's traditional 3" drill pattern B3 for easy fastening of LSI products.

Warranty

- LSI LED Fixtures carry a 5-year warranty.

Listings

- Listed to UL 1598 and UL 8750.
- Meets Buy American Act requirements.
- IDA compliant; with 3000K color temperature selection.
- Title 24 Compliant; see local ordinance for qualification information.
- Suitable for wet Locations.
- IP66 rated Luminaire per IEC 60598.
- 3G rated for ANSI C136.31 high vibration applications are qualified.
- DesignLights Consortium® (DLC) qualified product. Not all versions of this product may be DLC qualified. Please check the DLC Qualified Products List at www.designlights.org/QPL to confirm which versions are qualified.
- Patented Silicone Optics (US Patent NO. 10,816,165 B2)
- IK08 rated luminaire per IEC 66262 mechanical impact code



Mirada Medium Outdoor LED Area Light

Type : _____

Have questions? Call us at (800) 436-7800

ORDERING GUIDE

[Back to Quick Links](#)

TYPICAL ORDER EXAMPLE: MRM LED 36L SIL FTA UNV DIM 50 70CRI ALS04 BRZ IL							
Prefix	Light Source	Lumen Package	Lens	Distribution	Orientation ²	Voltage	Driver
MRM - Mirada Medium Area Light	LED	7L - 7,000 lms, 48W 9L - 9,000 lms, 62W 12L - 12,000 lms, 85W 18L - 18,000 lms, 135W 24L - 24,000 lms, 176W 30L - 30,000 lms, 232W 36L - 36,000 lms, 288W 42L - 42,000 lms, 314W 48L - 48,000 lms, 401W 55L - 55,000 lms, 438W Custom Lumen Packages ¹	SIL - Silicone	2 - Type 2 3 - Type 3 F1 4 - Type 4 5W - Type 5 Wide FT - Forward Throw F2 FTA - Forward Throw Automotive AM - Automotive Merchandise LC - Left Corner RC - Right Corner	(blank) - standard L - Optics rotated left 90° R - Optics rotated right 90°	UNV - Universal Voltage (120-277V) HV - High Voltage (347-480V)	DIM - 0-10V Dimming (0-10%)
Color Temp		Color Rendering	Finish		Options		
50 - 5,000 CCT 40 - 4,000 CCT 30 - 3,000 CCT AMB - Phosphor Converted Amber ¹²		70CRI - 70 CRI	BLK - Black BRZ - Dark Bronze GMG - Gun Metal Gray GPT - Graphite MSV - Metallic Silver PLP - Platinum Plus SVG - Satin Verde Green WHT - White		(Blank) - None IH - Integral Half Louver (Moderate Spill Light Cutoff) ² IL - Integral Louver (Sharp Spill Light Cutoff) ²		

Controls (Choose One)

(Blank) - None

Wireless Controls System

- ALSC - AirLink Synapse Control System
- ALSC02 - AirLink Synapse Control System with 12-20' Motion Sensor
- ALSC04 - AirLink Synapse Control System with 20-40' Motion Sensor
- ALBCS1 - AirLink Blue Wireless Motion & Photo Sensor Controller (8-24' mounting height)⁵
- ALBCS2 - AirLink Blue Wireless Motion & Photo Sensor Controller (25-40' mounting height)⁵

Stand-Alone Controls

- EXT - 0-10V Dimming leads extended to housing exterior
- CR7P - 7 Pin Control Receptacle ANSI C136.41⁶
- IMSBTL1 - Integral Bluetooth™ Motion and Photocell Sensor (8-24' MH)⁵
- IMSBTL2 - Integral Bluetooth™ Motion and Photocell Sensor (25-40' MH)⁵

Button Type Photocells

- PCI120 - 120V
- PCI208-277 - 208 - 277V
- PCI347 - 347V



Need more information?
Click here for our glossary

Have additional questions?
Call us at (800) 436-7800



ACCESSORY ORDERING INFORMATION⁷

CONTROLS ACCESSORIES	
Description	Order Number
PC120 Photocell for use with CR7P option (120V) ⁸	122514
PC208-277 Photocell for use with CR7P option (208V, 240V, 277V) ⁸	122515
Twist Lock Photocell (347V) for use with CR7P ⁸	122516
Twist Lock Photocell (480V) for use with CR7P ⁸	1225180
AirLink 5 Pin Twist Lock Controller ⁸	661409
AirLink 7 Pin Twist Lock Controller ⁸	661410
Shorting Cap for use with CR7P	149328

FUSING OPTIONS ¹¹	
Single Fusing (120V)	See Fusing Accessory Guide
Single Fusing (277V)	
Double Fusing (208V, 240V)	
Double Fusing (480V)	
Double Fusing (347V)	

SHIELDING OPTIONS	
Mirada Small	See Shielding Guide
Mirada Medium	
Mirada Large	
Zone Medium	
Zone Large	
Slice Medium	

1. Custom lumen and wattage packages available, consult factory. Values are within industry standard tolerances but not DLC listed.

2. Not available with 5W distribution

3. Consult Factory for availability.

4. Not available in HV.

5. Motion sensors are field configurable via an app that can be downloaded from your smartphone's native app store. See controls section for more details.

6. Control device or shorting cap must be ordered separately. See Accessory Ordering Information.
7. Accessories are shipped separately and field installed.

8. Factory installed CR7P option required. See Options.

9. "CLR" denotes finish. See Finish options.

10. Only available with ALSC/ALSCH control options.

11. Fusing must be located in hand hole of pole. See [Fusing Accessory Guide](#) for compatibility.


12. Only available in 9L, 12L, 18L and 24L Lumen Packages. Consult factory for lead time and availability.

Mirada Medium Outdoor LED Area Light

Type : _____


 Have questions? Call us at (800) 436-7800

ACCESSORIES

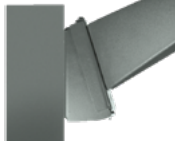MOUNTING ACCESSORIES			SHIELDING, POLES & MISC. ACCESSORIES		
Side Arm	Universal Mounting Bracket Mounts to ≥ 3" square or round (tapered/straight) poles with (2) mounting hole spaces between 3.5" to 5" Part Number: BKA UMB CLR		Shielding	Integral Louver Field Install Integral Louver provides maximum backlight control by shielding each individual row of LEDs Part Number: 690981	
	Quick Mount Plate True one person installation to existing/new construction poles with hole spaces between 2.4 to 4.6" Part Number: BKS PQM B3B5 XX CLR			Integral Half Louver Field Install Integral Half Louver provides great backlight control without impacting front side distribution. Part Number: 743415	
	15° Tilt Quick Mount Plate True one person installation to existing/new construction poles with hole spaces between 2.4 to 4.6" Part Number: BKS PQ15 B3B5 XX CLR			External Shield External shield blocks view of light source from anyside of luminaire, additional shielding configurations available Part Number: 783607BLK (3") / 776538BLK (6")	
Tenon / Slipfitter	Adjustable Slipfitter Mounts onto a 2" (51mm) IP, 2.375" (60mm) O.D. tenon and provides 180° of tilt (max 45° above horizontal) Part Number: BKA ASF CLR		Poles	Square Poles 14 - 39" steel and aluminum poles in 4", 5" and 6" sizes for retrofit and new construction Part Number: 4SQ/5SQ/6SQ	
	Square Tenon Top Mounts onto a 2" (51mm) IP, 2.375" (60mm) O.D. tenon and allows for mounting up to 4 luminaires Part Number: BKA XNM *			Round Poles 10 - 30" steel and aluminum poles in 4" and 5" sizes for retrofit and new construction Part Number: 4RP/5RP	
	Square Internal Slipfitter Mounts inside 4" or 5" square pole and allows for mounting up to 4 luminaires Part Number: BKA X_ISF * CLR			Tapered Poles 20' - 39" steel and aluminum poles for retrofit and new construction Part Number: RTP	
Wall Mount/ Wood Pole	Wall Mount Bracket Mounts onto vertical wall surface (hardware/anchors not included) Part Number: BKS XBO WM CLR		Misc.	Bird Spikes 10' Linear Bird Spike Kit, 4' recommended per luminaire, includes silicone adhesive and application tool Part Number: 736795	
	Wood Pole Bracket Mounts onto wooden poles (6" minimum OD, hardware/anchors not included) Part Number: BKS XBO WP CLR			Replace CLR with paint finish description Replace XX with SQ for square pole or RD for round pole (≥3" OD) Replace * with S (Single), D180 (Double @180°), D90 (Double @90°), T90 (Triple), Q90 (Quad) Replace _ with 4 (4" square pole) or 5 (5" square pole)	

OPTICS ROTATION

Top View

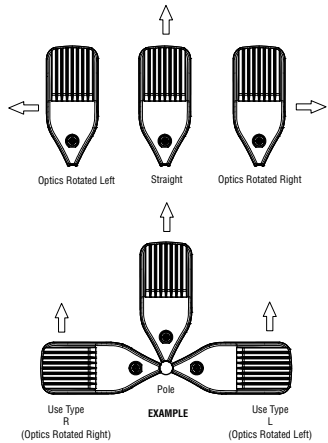

ACCESSORIES/OPTIONS

Integral Louver (IL) and House-Side Shield (IH)

Integral louver (IL) and half louver (IH) accessory shields available for improved backlight control without sacrificing street side performance. LSI's Integral Louver (IL) and Integral House-Side Shield (IH) options deliver backlight control that significantly reduces spill light behind the poles for applications with pole locations close to adjacent properties. The design maximizes forward reflected light while reducing glare, maintaining the optical distribution selected, and most importantly eliminating light trespass. Both options rotate

Luminaire Shown with Integral Louver (IL)



Luminaire Shown with IMSBTL Option



7 Pin Photoelectric Control

7-pin ANSI C136.41-2013 control receptacle option available for twist lock photocontrols or wireless control modules. Control accessories sold separately. Dimming leads from the receptacle will be connected to the driver dimming leads (Consult factory for alternate wiring).

Luminaire Shown with CR7P



Mirada Medium Outdoor LED Area Light

Type : _____

 Have questions? Call us at (800) 436-7800

PERFORMANCE

[Back to Quick Links](#)

DELIVERED LUMENS*												
Lumen Package	Distribution	CRI	3000K CCT			4000K CCT			5000K CCT			Wattage
			Delivered Lumens	Efficacy	BUG Rating	Delivered Lumens	Efficacy	BUG Rating	Delivered Lumens	Efficacy	BUG Rating	
9L	2	70	9853	159	B2-U0-G2	9853	159	B2-U0-G2	9853	159	B2-U0-G2	62
	3		9926	160	B2-U0-G2	9926	160	B2-U0-G2	9926	160	B2-U0-G2	
	4		9178	148	B2-U0-G3	9713	157	B2-U0-G3	9498	153	B2-U0-G3	
	5W		9504	153	B3-U0-G2	9504	153	B3-U0-G2	9504	153	B3-U0-G2	
	FT		9856	159	B2-U0-G3	9856	159	B2-U0-G3	9856	159	B2-U0-G3	
	FTA		9900	160	B2-U0-G2	9900	160	B2-U0-G2	9900	160	B2-U0-G2	
	AM		10019	162	B2-U0-G1	10019	162	B2-U0-G1	10019	162	B2-U0-G1	
	LC/RC		9008	145	B2-U0-G3	9533	154	B2-U0-G3	9321	150	B2-U0-G3	
12L	2	70	13135	155	B3-U0-G2	13135	155	B3-U0-G2	13135	155	B3-U0-G2	85
	3		13232	156	B2-U0-G2	13232	156	B2-U0-G2	13232	156	B2-U0-G2	
	4		12223	144	B2-U0-G3	12935	152	B2-U0-G4	12648	149	B2-U0-G4	
	5W		12669	149	B4-U0-G2	12669	149	B4-U0-G2	12669	149	B4-U0-G2	
	FT		13138	155	B2-U0-G3	13138	155	B2-U0-G3	13138	155	B2-U0-G3	
	FTA		13196	155	B2-U0-G2	13196	155	B2-U0-G2	13196	155	B2-U0-G2	
	AM		13355	157	B2-U0-G2	13355	157	B2-U0-G2	13355	157	B2-U0-G2	
	LC/RC		11996	141	B2-U0-G3	12695	149	B2-U0-G3	12414	146	B2-U0-G3	
18L	2	70	19318	143	B3-U0-G3	19318	143	B3-U0-G3	19318	143	B3-U0-G3	135
	3		19461	144	B3-U0-G3	19461	144	B3-U0-G3	19461	144	B3-U0-G3	
	4		18013	133	B2-U0-G4	19063	141	B3-U0-G5	18640	138	B3-U0-G5	
	5W		18633	138	B4-U0-G2	18633	138	B4-U0-G2	18633	138	B4-U0-G2	
	FT		19324	143	B3-U0-G3	19324	143	B3-U0-G3	19324	143	B3-U0-G3	
	FTA		19408	144	B3-U0-G3	19408	144	B3-U0-G3	19408	144	B3-U0-G3	
	AM		19641	145	B3-U0-G2	19641	145	B3-U0-G2	19641	145	B3-U0-G2	
	LC/RC		17679	131	B2-U0-G3	18710	139	B2-U0-G3	18295	136	B2-U0-G3	
24L	2	70	23361	145	B4-U0-G3	24506	152	B4-U0-G3	24414	152	B4-U0-G3	161
	3		23998	149	B3-U0-G3	25174	156	B3-U0-G3	25079	156	B3-U0-G3	
	4		24397	152	B3-U0-G5	25600	160	B3-U0-G5	25457	159	B3-U0-G5	
	5W		23788	148	B5-U0-G3	24953	155	B5-U0-G3	24859	154	B5-U0-G3	
	FT		24059	149	B3-U0-G3	25238	157	B3-U0-G3	25143	156	B3-U0-G3	
	FTA		23079	143	B3-U0-G3	24210	150	B4-U0-G3	24119	150	B4-U0-G3	
	AM		24051	149	B3-U0-G2	25229	157	B3-U0-G2	25134	156	B3-U0-G2	
	LC/RC		25884	162	B3-U0-G4	25884	162	B3-U0-G4	25310	158	B3-U0-G4	
30L	2	70	29464	138	B4-U0-G3	30908	145	B4-U0-G3	30791	145	B4-U0-G3	213
	3		30268	142	B3-U0-G4	31751	149	B3-U0-G4	31631	149	B3-U0-G4	
	4		30631	144	B3-U0-G5	32141	151	B3-U0-G5	31961	150	B3-U0-G5	
	5W		30002	141	B5-U0-G3	31472	148	B5-U0-G3	31353	147	B5-U0-G3	
	FT		30345	142	B4-U0-G4	31832	149	B4-U0-G4	31712	149	B4-U0-G4	
	FTA		29109	137	B4-U0-G4	30535	143	B4-U0-G4	30420	143	B4-U0-G4	
	AM		30334	142	B4-U0-G3	31820	149	B4-U0-G3	31700	149	B4-U0-G3	
	LC/RC		32498	153	B3-U0-G5	32498	153	B3-U0-G5	31777	149	B3-U0-G5	

*LEDs are frequently updated therefore values are nominal.

Mirada Medium Outdoor LED Area Light

Type : _____

 Have questions? Call us at (800) 436-7800

PERFORMANCE (CONT.)

DELIVERED LUMENS*												
Lumen Package	Distribution	CRI	3000K CCT			4000K CCT			5000K CCT			Wattage
			Delivered Lumens	Efficacy	BUG Rating	Delivered Lumens	Efficacy	BUG Rating	Delivered Lumens	Efficacy	BUG Rating	
36L	2	70	34123	134	B4-U0-G3	35795	140	B4-U0-G3	35660	140	B4-U0-G3	255
	3		35053	137	B4-U0-G4	36771	144	B4-U0-G4	36632	144	B4-U0-G4	
	4		35402	139	B3-U0-G5	37148	146	B4-U0-G5	36940	145	B4-U0-G5	
	5W		34745	136	B5-U0-G4	36448	143	B5-U0-G4	36311	142	B5-U0-G4	
	FT		35142	138	B4-U0-G4	36864	145	B4-U0-G4	36725	144	B4-U0-G4	
	FTA		33711	132	B4-U0-G4	35363	139	B4-U0-G4	35230	138	B4-U0-G4	
	AM		35130	138	B4-U0-G3	36851	145	B4-U0-G3	36712	144	B4-U0-G3	
	LC/RC		37561	147	B3-U0-G5	37561	147	B3-U0-G5	36727	144	B3-U0-G5	
42L	2	70	39966	127	B5-U0-G4	41925	134	B5-U0-G4	41767	133	B5-U0-G4	314
	3		41056	131	B4-U0-G5	43068	137	B4-U0-G5	42905	137	B4-U0-G5	
	4		41453	132	B4-U0-G5	43497	138	B4-U0-G5	43254	138	B4-U0-G5	
	5W		40696	130	B5-U0-G4	42690	136	B5-U0-G4	42529	135	B5-U0-G4	
	FT		41161	131	B4-U0-G4	43178	138	B4-U0-G4	43015	137	B4-U0-G4	
	FTA		39484	126	B4-U0-G4	41419	132	B5-U0-G4	41263	131	B5-U0-G4	
	AM		41146	131	B4-U0-G3	43162	137	B4-U0-G3	43000	137	B4-U0-G3	
	LC/RC		43980	140	B3-U0-G5	43980	140	B3-U0-G5	43004	137	B3-U0-G5	
48L	2	70	44390	121	B5-U0-G4	46565	127	B5-U0-G4	46389	126	B5-U0-G4	367
	3		45325	124	B4-U0-G5	47547	130	B4-U0-G5	47367	129	B4-U0-G5	
	4		46006	126	B4-U0-G5	48275	132	B4-U0-G5	48005	131	B4-U0-G5	
	5W		45002	123	B5-U0-G4	47435	129	B5-U0-G4	47302	129	B5-U0-G4	
	FT		44799	122	B4-U0-G5	46994	128	B4-U0-G5	46817	128	B4-U0-G5	
	FTA		44590	121	B5-U0-G4	46775	127	B5-U0-G4	46599	128	B5-U0-G4	
	AM		46310	126	B4-U0-G3	48579	132	B4-U0-G3	48396	132	B4-U0-G3	
	LC/RC		48811	133	B4-U0-G5	48811	133	B4-U0-G5	47728	130	B4-U0-G5	
55L	2	70	49583	114	B5-U0-G4	52012	119	B5-U0-G4	51816	119	B5-U0-G4	436
	3		50934	117	B4-U0-G5	53430	123	B4-U0-G5	53229	122	B4-U0-G5	
	4		51635	119	B4-U0-G5	54181	125	B4-U0-G5	53878	124	B4-U0-G5	
	5W		50487	116	B5-U0-G4	52961	121	B5-U0-G4	52761	121	B5-U0-G4	
	FT		51064	117	B4-U0-G5	53566	123	B4-U0-G5	53364	122	B4-U0-G5	
	FTA		48984	112	B5-U0-G4	51384	118	B5-U0-G4	51191	117	B5-U0-G4	
	AM		51045	117	B4-U0-G3	53546	123	B4-U0-G3	53344	122	B4-U0-G3	
	LC/RC		54113	124	B4-U0-G5	54113	124	B4-U0-G5	52912	121	B4-U0-G5	

*LEDs are frequently updated therefore values are nominal.

Mirada Medium Outdoor LED Area Light

Type : _____

 Have questions? Call us at (800) 436-7800

PERFORMANCE (CONT.)

ELECTRICAL DATA (AMPS)*						
Lumens	120V	208V	240V	277V	347V	480V
9L	0.52	0.30	0.26	0.22	0.18	0.13
12L	0.71	0.41	0.35	0.31	0.24	0.18
18L	1.13	0.65	0.56	0.49	0.39	0.28
24L	1.33	0.77	0.67	0.58	0.46	0.33
30L	1.78	1.02	0.89	0.77	0.61	0.44
36L	2.12	1.22	1.06	0.92	0.73	0.53
42L	2.62	1.51	1.31	1.13	0.90	0.65
48L	3.05	1.76	1.53	1.32	1.05	0.76
55L	3.65	2.11	1.83	1.58	1.26	0.91

RECOMMENDED LUMEN MAINTENANCE¹ (0-25°C)					
Ambient	Initial²	25h²	50hr²	75hr²	100hr²
9L - 18L	100%	97%	93%	90%	86%
24L - 48L	100%	95%	89%	84%	79%
55L	100%	91%	82%	74%	67%

RECOMMENDED LUMEN MAINTENANCE¹ (40°C)					
Ambient	Initial²	25h²	50hr²	75hr²	100hr²
9L - 18L	100%	97%	92%	88%	84%
24L - 48L	100%	94%	87%	80%	74%

RECOMMENDED LUMEN MAINTENANCE¹ (50°C)					
Ambient	Initial²	25h²	50hr²	75hr²	100hr²
9L - 18L C	100%	96%	91%	87%	83%

*Electrical data at 25°C (77°F). Actual wattage may differ by +/-10%

1. Lumen maintenance values at 25C are calculated per TM-21 based on LM-80 data and in-situ testing.
2. In accordance with IESNA TM-21-11, Projected Values represent interpolated value based on time durations that are within six times the IESNA LM-80-08 total test duration for the device under testing.
3. In accordance with IESNA TM-21-11, Calculated Values represent time durations that exceed six times the IESNA LM-80-08 total test duration for the device under testing.

DELIVERED LUMENS*					
Lumen Package	Distribution	Phosphor Converted Amber (Peak 610nm)			Wattage
		Delivered Lumens	Efficacy	BUG Rating	
9L	2	5848	80	B2-U0-G2	74
	3	6018	82	B1-U0-G2	
	5W	5471	74	B3-U0-G1	
	FT	5801	79	B1-U0-G2	
	FTA	5924	81	B1-U0-G1	
	AM	5995	81	B1-U0-G1	
12L	2	7530	74	B2-U0-G2	102
	3	7749	76	B1-U0-G2	
	5W	7045	69	B3-U0-G2	
	FT	7470	73	B2-U0-G2	
	FTA	7628	75	B2-U0-G2	
	AM	7720	76	B1-U0-G1	
18L	2	9311	69	B2-U0-G2	135
	3	9582	71	B2-U0-G2	
	5W	8712	65	B3-U0-G2	
	FT	9237	68	B2-U0-G2	
	FTA	9433	70	B2-U0-G2	
	AM	9546	71	B2-U0-G1	
24L	2	10955	63	B2-U0-G2	175
	3	11273	64	B2-U0-G2	
	5W	10249	59	B3-U0-G2	
	FT	10867	62	B2-U0-G2	
	FTA	11097	63	B2-U0-G2	
	AM	11230	64	B2-U0-G1	

ELECTRICAL DATA - PHOSPHOR CONVERTED AMBER (AMPS)*						
Lumens	120V	208V	240V	277V	347V	480V
9L	0.62	0.36	0.31	0.27	0.21	0.15
12L	0.85	0.50	0.43	0.38	0.30	0.22
18L	1.13	0.65	0.56	0.49	0.39	0.28
24L	1.47	0.85	0.73	0.64	0.51	0.37

*LEDs are frequently updated therefore values are nominal.

Mirada Medium Outdoor LED Area Light

Type : _____

 Have questions? Call us at (800) 436-7800

PHOTOMETRICS

[Back to Quick Links](#)

Luminaire photometry has been conducted by a NVLAP accredited testing laboratory in accordance with IESNA LM-79-08. As specified by IESNA LM-79-08 the entire luminaire is tested as the source resulting in a luminaire efficiency of 100%.


See the individual product page on <https://www.isicorp.com/> for detailed photometric data.

MRM-LED-30L-SIL-2-40-70CRI

Luminaire Data	
Type 2 Distribution	
Description	4000 Kelvin, 70 CRI
Delivered Lumens	32,416
Watts	232
Efficacy	140
IES Type	Type II - Short
BUG Rating	B4-U0-G3


Zonal Lumen Summary		
Zone	Lumens	% Luminaire
Low (0-30°)	4796	15%
Medium (30-60°)	19811	61%
High (60-80°)	7474	23%
Very High (80-90°)	335	1%
Uplight (90-180°)	0	0%
Total Flux	32416	100%

ISO Footcandle

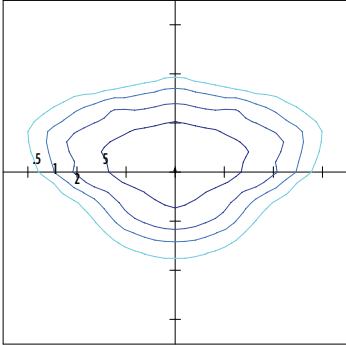

25' Mounting Height / 25' Grid Spacing
■ 5 FC ■ 2 FC ■ 1 FC ■ 0.5 FC

Polar Curve

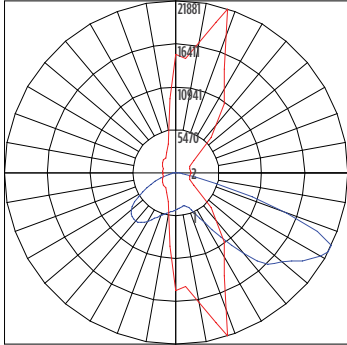


■ Vertical Plane ■ Horizontal Cone

MRM-LED-30L-SIL-3-40-70CRI

Luminaire Data	
Type 3 Distribution	
Description	4000 Kelvin, 70 CRI
Delivered Lumens	32,656
Watts	232
Efficacy	141
IES Type	Type III - Short
BUG Rating	B3-U0-G4


Zonal Lumen Summary		
Zone	Lumens	% Luminaire
Low (0-30°)	3385	10%
Medium (30-60°)	16250	50%
High (60-80°)	12430	38%
Very High (80-90°)	591	2%
Uplight (90-180°)	0	0%
Total Flux	32656	100%

ISO Footcandle

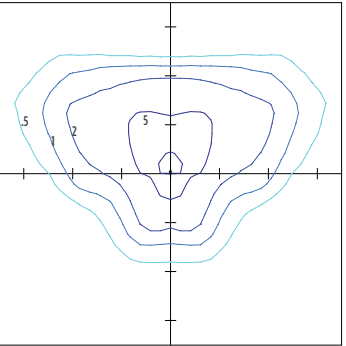

25' Mounting Height / 25' Grid Spacing
■ 5 FC ■ 2 FC ■ 1 FC ■ 0.5 FC

Polar Curve

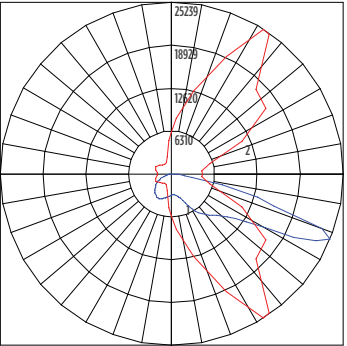


■ Vertical Plane ■ Horizontal Cone

MRM-LED-30L-SIL-FT-40-70CRI

Luminaire Data	
Type FT Distribution	
Description	4000 Kelvin, 70 CRI
Delivered Lumens	32,424
Watts	232
Efficacy	140
IES Type	Type IV - Short
BUG Rating	B3-U0-G4


Zonal Lumen Summary		
Zone	Lumens	% Luminaire
Low (0-30°)	3952	12%
Medium (30-60°)	15505	48%
High (60-80°)	12279	38%
Very High (80-90°)	688	2%
Uplight (90-180°)	0	0%
Total Flux	32424	100%

ISO Footcandle

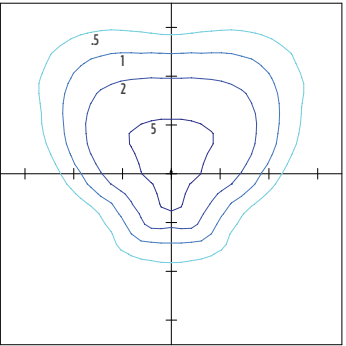

25' Mounting Height / 25' Grid Spacing
■ 5 FC ■ 2 FC ■ 1 FC ■ 0.5 FC

Polar Curve

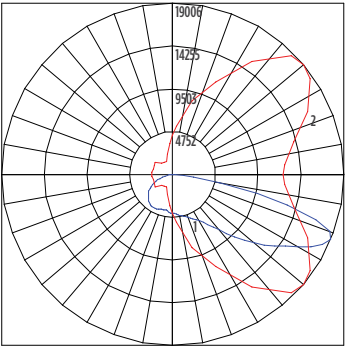

■ Vertical Plane ■ Horizontal Cone

Mirada Medium Outdoor LED Area Light

Type : _____



 Have questions? Call us at (800) 436-7800

PHOTOMETRICS (CONT)

MRM-LED-30L-SIL-4-40-70CRI

Luminaire Data	
Type 4 Distribution	
Description	4000 Kelvin, 70 CRI
Delivered Lumens	32,141
Watts	213
Efficacy	151
IES Type	Type IV - Very Short
BUG Rating	B3-U0-G5



Zonal Lumen Summary		
Zone	Lumens	% Luminaire
Low (0-30°)	3119	10%
Medium (30-60°)	13569	42%
High (60-80°)	13649	42%
Very High (80-90°)	1804	6%
Uplight (90-180°)	0	0%
Total Flux	32141	100%

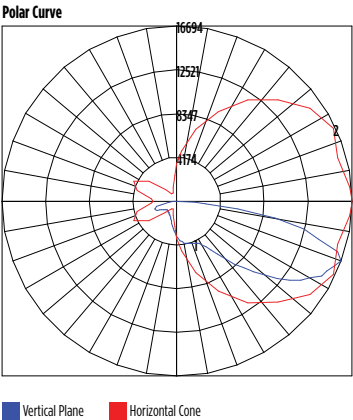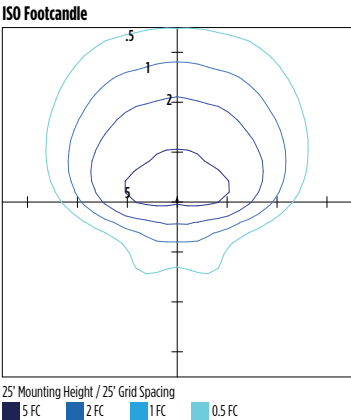

MRM-LED-30L-SIL-5W-40-70CRI

Luminaire Data	
Type 5W Distribution	
Description	4000 Kelvin, 70 CRI
Delivered Lumens	31,267
Watts	232
Efficacy	135
IES Type	Type VS - Short
BUG Rating	B5-U0-G3



Zonal Lumen Summary		
Zone	Lumens	% Luminaire
Low (0-30°)	3138	10%
Medium (30-60°)	13193	42%
High (60-80°)	14641	47%
Very High (80-90°)	296	1%
Uplight (90-180°)	0	0%
Total Flux	31267	100%

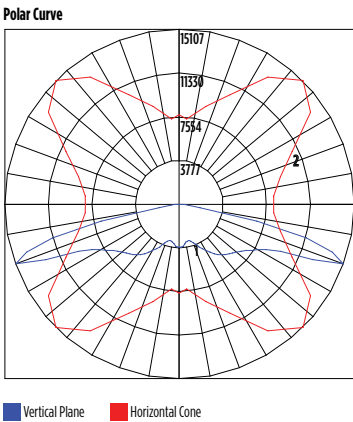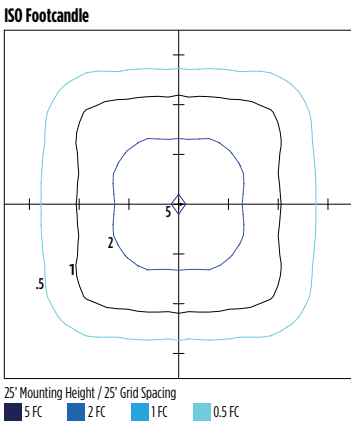

MRM-LED-30L-SIL-FTA-40-70CRI

Luminaire Data	
Type FTA Distribution	
Description	4000 Kelvin, 70 CRI
Delivered Lumens	32,566
Watts	232
Efficacy	140
IES Type	Type VS - Short
BUG Rating	B4-U0-G3

Zonal Lumen Summary		
Zone	Lumens	% Luminaire
Low (0-30°)	6986	21%
Medium (30-60°)	19172	59%
High (60-80°)	5875	18%
Very High (80-90°)	534	2%
Uplight (90-180°)	0	0%
Total Flux	32566	100%

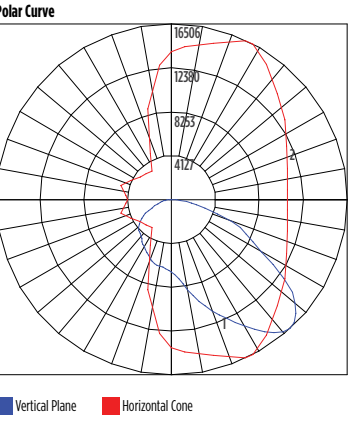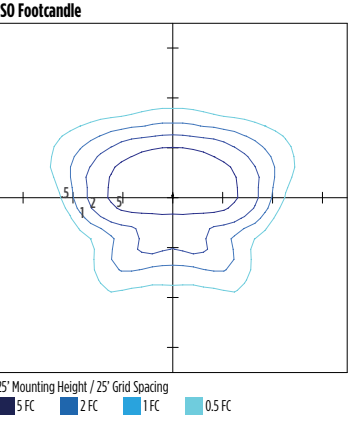

Mirada Medium Outdoor LED Area Light

Type : _____

 Have questions? Call us at (800) 436-7800

PHOTOMETRICS (CONT)


[Back to Quick Links](#)

MRM-LED-30L-SIL-AM-40-70CRI

Luminaire Data	
Type AM Distribution	
Description	4000 Kelvin, 70 CRI
Delivered Lumens	32,960
Watts	232
Efficacy	142
IES Type	Type III - Very Short
BUG Rating	B3-U0-G3


Zonal Lumen Summary		
Zone	Lumens	% Luminaire
Low (0-30°)	6363	19%
Medium (30-60°)	22026	67%
High (60-80°)	4192	13%
Very High (80-90°)	379	1%
Uplight (90-180°)	0	0%
Total Flux	32960	100%

ISO Footcandle

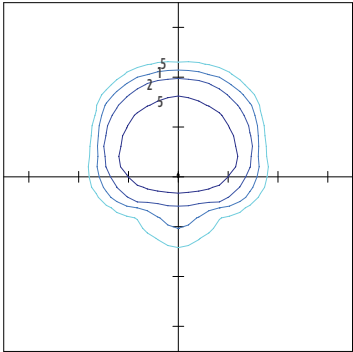

25' Mounting Height / 25' Grid Spacing
■ 5 FC ■ 2 FC ■ 1 FC ■ 0.5 FC

Polar Curve

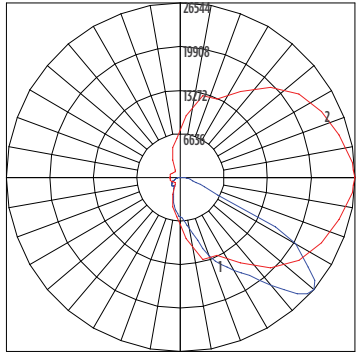


■ Vertical Plane ■ Horizontal Cone

MRM-LED-30L-SIL-LC-40-70CRI

Luminaire Data	
Left Corner Distribution	
Description	4000 Kelvin, 70 CRI
Delivered Lumens	32,498
Watts	213
Efficacy	153
IES Type	N/A
BUG Rating	B3-U0-G5


Zonal Lumen Summary		
Zone	Lumens	% Luminaire
Low (0-30°)	5083	16%
Medium (30-60°)	14808	46%
High (60-80°)	11603	36%
Very High (80-90°)	1005	3%
Uplight (90-180°)	0	0%
Total Flux	32498	100%

ISO Footcandle

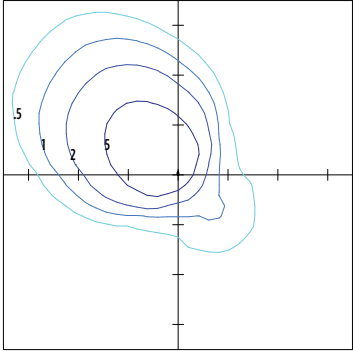

25' Mounting Height / 25' Grid Spacing
■ 5 FC ■ 2 FC ■ 1 FC ■ 0.5 FC

Polar Curve

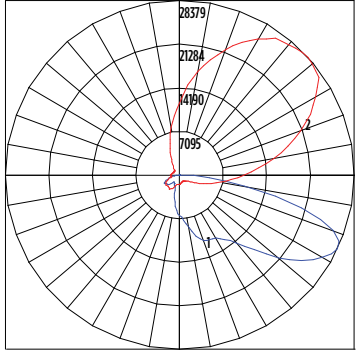


■ Vertical Plane ■ Horizontal Cone

MRM-LED-30L-SIL-RC-40-70CRI

Luminaire Data	
Right Corner Distribution	
Description	4000 Kelvin, 70 CRI
Delivered Lumens	32,498
Watts	213
Efficacy	153
IES Type	N/A
BUG Rating	B3-U0-G5


Zonal Lumen Summary		
Zone	Lumens	% Luminaire
Low (0-30°)	5083	16%
Medium (30-60°)	14808	46%
High (60-80°)	11603	36%
Very High (80-90°)	1005	3%
Uplight (90-180°)	0	0%
Total Flux	32498	100%

ISO Footcandle

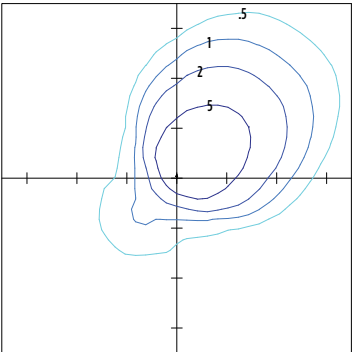

25' Mounting Height / 25' Grid Spacing
■ 5 FC ■ 2 FC ■ 1 FC ■ 0.5 FC

Polar Curve

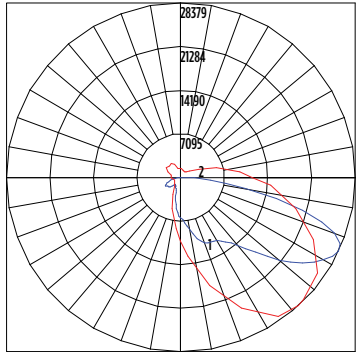


■ Vertical Plane ■ Horizontal Cone

Mirada Medium Outdoor LED Area Light

Type : _____

 Have questions? Call us at (800) 436-7800

PRODUCT DIMENSIONS

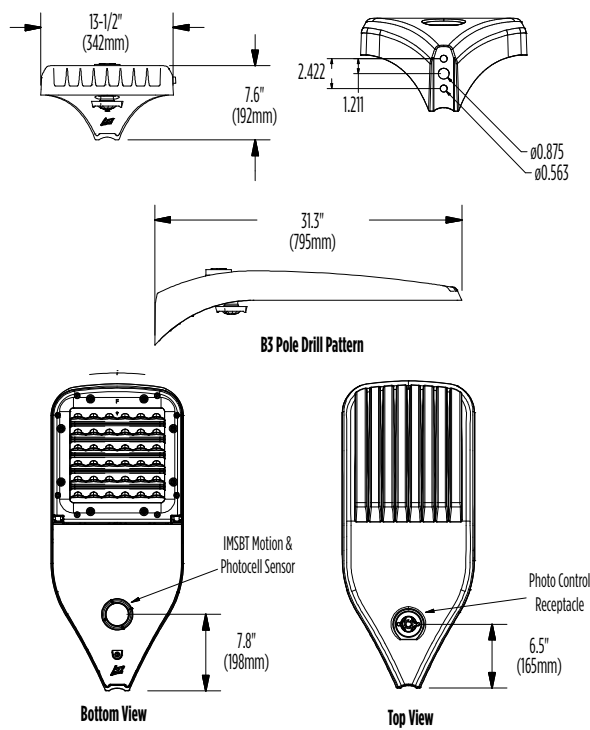

Luminaire EPA Chart					
Tilt Degree		0°	15°	30°	45°
	Single	0.5	1.0	1.5	1.9
	D180°	1.0	1.5	1.5	1.9
	D90°	0.8	1.8	1.9	2.3
	T90°	1.0	4.0	2.5	2.8
	TN120°	1.0	2.9	3.3	3.9
	Q90°	1.0	4.0	2.5	2.8

Mirada Medium Outdoor LED Area Light

Type : _____

 Have questions? Call us at (800) 436-7800

CONTROLS

Integral Bluetooth™ Motion and Photocell Sensor (IMSBTxL)

Slim low profile sensor provides multi-level control based on motion and/or daylight. Sensor controls 0-10 VDC LED drivers and is IP66 rated for cold and wet locations (-40°F to 167°F). Two unique PIR lenses are available and used based on fixture mounting height. All control parameters are adjustable via an iOS or Android App capable of storing and transmitting sensor profiles.

[Click here to learn more details about IMSBT](#)



LEVITON App



Apple



Android

AirLink Blue (ALBCSx)

Wireless Bluetooth Mesh Outdoor Lighting Control System that provides energy savings, code compliance and enhanced safety/security for parking lots and parking garages. Three key components; Bluetooth wireless radio/sensor controller, Time Keeper and an iOS App. Capable of grouping multiple fixtures and sensors as well as scheduling time-based events by zone. Radio/Sensor Controller is factory integrated into Area/ Site, Wall Mounted, Parking Garage and Canopy luminaires.

[Click here to learn more details about AirLink Blue](#)



AirLink Blue App



Apple

Sensor Sequence of Operations

Standard Programming	On Event	Off Event	On Light Level	Dim Light Level	Daylight Harvesting	Delay To Off	Sensitivity
OMSBTxL/IMSBTxL	Motion	No Motion	100%	N/A	On; Auto Calibration	20 minutes	High
OMS	Motion	No Motion	N/A	N/A	N/A	30 seconds	Auto

Operation	Description
On Event	Trigger that activates lights to turn on; either automatic via motion detected or manually activated via push of button.
Off Event	Trigger that activates lights to turn off; either automatic via no motion detected or manually activated via push of button.
On Light Level	The light level that the fixtures will turn on to when ON EVENT occurs.
Dim Light Level	The light level that the fixtures will dim down to when no motion is detected.
Delay to Dim	The amount of time after which no motion is detected that the fixtures will be triggered to dim down. This sequence is optional, and sensor can be programmed to only trigger the fixture to turn off by entering 100% in this field.
Delay to Off	The amount of time after which no motion is detected that the fixtures will be triggered to turn off. If delay to dim is part of the programmed functionality, this is the amount of time after which no motion is detected after the fixture have already dimmed down.
Sensitivity	The sensitivity can be set to high, medium, low, or auto where applicable. High will detect smaller, simple motions. Low will only detect larger more complex motions. Auto temperature calibration adjusts the PIR sensitivity as ambient temperature rises to increase detection of heat movement through the field of view.





Mirada Medium (MRM)

Outdoor LED Area Light



IP66 IK08



OVERVIEW

Lumen Package	7,000 - 55,000
Wattage Range	48 - 438
Efficacy Range (LPW)	115 - 162
Weight lbs(kg)	30 (13.6)
Control Options	IMSBT, ALB, ALS, 7-Pin, PCI

QUICK LINKS

[Ordering Guide](#)[Performance](#)[Photometrics](#)[Dimensions](#)

FEATURES & SPECIFICATIONS

Construction

- Rugged die-cast aluminum housing contains factory prewired driver and optical unit. Cast aluminum wiring access door located underneath.
- Designed to mount to square or round poles.
- Fixtures are finished with LSI's DuraGrip® polyester powder coat finishing process. The DuraGrip finish withstands extreme weather changes without cracking or peeling. Other standard LSI finishes available. Consult factory.
- Shipping weight: 37 lbs in carton.

Optical System

- State-of-the-Art one piece silicone optic sheet delivers industry leading optical control with an integrated gasket to provide IP66 rated sealed optical chamber in 1 component.
- Proprietary silicone refractor optics provide exceptional coverage and uniformity in IES Types 2, 3, 4, 5W, FT, FTA, AM, and LC/RC.
- Silicone optical material does not yellow or crack with age and provides a typical light transmittance of 93-95%.
- Zero uplight.
- Available in 5000K, 4000K, and 3000K color temperatures per ANSI C78.377. Also Available in Phosphor Converted Amber with Peak intensity at 610nm.
- Minimum CRI of 70.
- Integral louver (IL) and integral half louver (IH) options available for enhanced backlight control.

Electrical

- High-performance programmable driver features over-voltage, under-voltage, short-circuit and over temperature protection. Custom lumen and wattage packages available.
- 0-10V dimming (10% - 100%) standard.
- Standard Universal Voltage (120-277 Vac) Input 50/60 Hz or optional High Voltage (347-480 Vac).
- L80 Calculated Life: >100k Hours (See Lumen Maintenance chart)
- Total harmonic distortion: <20%
- Operating temperature: -40°C to +50°C (-40°F to +122°F). 42L and 48L lumen packages rated to +40°C. 55L lumen package rate to +35°C.
- Power factor: >.90
- Input power stays constant over life.
- Field replaceable 10kV surge protection device meets a minimum Category C Low operation (per ANSI/IEEE C62.41.2).
- High-efficacy LEDs mounted to metal-core circuit board to maximize heat dissipation
- Components are fully encased in potting material for moisture resistance. Driver complies with FCC standards. Driver and key electronic components can easily be accessed.

Controls

- Optional integral passive infrared Bluetooth™ motion. Fixtures operate independently and can be commissioned via iOS or Android configuration app
- LSI's AirLink™ wireless control system options reduce energy and maintenance

costs while optimizing light quality 24/7. (see controls section for more details).

Installation

- Designed to mount to square or round poles.
- A single fastener secures the hinged door, underneath the housing and provides quick & easy access to the electrical compartment.
- Included terminal block accepts up to 12 ga. wire.
- Utilizes LSI's traditional 3" drill pattern B3 for easy fastening of LSI products.

Warranty

- LSI LED Fixtures carry a 5-year warranty.

Listings

- Listed to UL 1598 and UL 8750.
- Meets Buy American Act requirements.
- IDA compliant; with 3000K color temperature selection.
- Title 24 Compliant; see local ordinance for qualification information.
- Suitable for wet Locations.
- IP66 rated Luminaire per IEC 60598.
- 3G rated for ANSI C136.31 high vibration applications are qualified.
- DesignLights Consortium® (DLC) qualified product. Not all versions of this product may be DLC qualified. Please check the DLC Qualified Products List at www.designlights.org/QPL to confirm which versions are qualified.
- Patented Silicone Optics (US Patent NO. 10,816,165 B2)
- IK08 rated luminaire per IEC 66262 mechanical impact code



Mirada Medium Outdoor LED Area Light

Type : _____

Have questions? Call us at (800) 436-7800

ORDERING GUIDE

[Back to Quick Links](#)

TYPICAL ORDER EXAMPLE: MRM LED 36L SIL FTA UNV DIM 50 70CRI ALS04 BRZ IL							
Prefix	Light Source	Lumen Package	Lens	Distribution	Orientation ²	Voltage	Driver
MRM - Mirada Medium Area Light	LED	7L - 7,000 lms, 48W 9L - 9,000 lms, 62W 12L - 12,000 lms, 85W 18L - 18,000 lms, 135W 24L - 24,000 lms, 176W 30L - 30,000 lms, 232W 36L - 36,000 lms, 288W 42L - 42,000 lms, 314W 48L - 48,000 lms, 401W 55L - 55,000 lms, 438W Custom Lumen Packages ¹	SIL - Silicone	2 - Type 2 3 - Type 3 4 - Type 4 5W - Type 5 Wide FT - Forward Throw FTA - Forward Throw Automotive AM - Automotive Merchandise LC - Left Corner RC - Right Corner	(blank) - standard L - Optics rotated left 90° R - Optics rotated right 90°	UNV - Universal Voltage (120-277V) HV - High Voltage (347-480V)	DIM - 0-10V Dimming (0-10%)
Color Temp		Color Rendering	Finish		Options		
50 - 5,000 CCT 40 - 4,000 CCT 30 - 3,000 CCT AMB - Phosphor Converted Amber ¹²		70CRI - 70 CRI	BLK - Black BRZ - Dark Bronze GMG - Gun Metal Gray GPT - Graphite		MSV - Metallic Silver PLP - Platinum Plus SVG - Satin Verde Green WHT - White (Blank) - None IH - Integral Half Louver (Moderate Spill Light Cutoff) ² IL - Integral Louver (Sharp Spill Light Cutoff) ²		

Controls (Choose One)

(Blank) - None

Wireless Controls System

- ALSC - AirLink Synapse Control System
- ALSC02 - AirLink Synapse Control System with 12-20' Motion Sensor
- ALSC04 - AirLink Synapse Control System with 20-40' Motion Sensor
- ALB051 - AirLink Blue Wireless Motion & Photo Sensor Controller (8-24' mounting height)⁵
- ALB052 - AirLink Blue Wireless Motion & Photo Sensor Controller (25-40' mounting height)⁵

Stand-Alone Controls

- EXT - 0-10V Dimming leads extended to housing exterior
- CR7P - 7 Pin Control Receptacle ANSI C136.41⁶
- IMSBTL1 - Integral Bluetooth™ Motion and Photocell Sensor (8-24' MH)⁵
- IMSBTL2 - Integral Bluetooth™ Motion and Photocell Sensor (25-40' MH)⁵

Button Type Photocells

- PC120 - 120V
- PC1208-277 - 208 - 277V
- PC1347 - 347V



Need more information?
Click here for our glossary

Have additional questions?
Call us at (800) 436-7800



ACCESSORY ORDERING INFORMATION⁷

CONTROLS ACCESSORIES	
Description	Order Number
PC120 Photocell for use with CR7P option (120V) ⁸	122514
PC208-277 Photocell for use with CR7P option (208V, 240V, 277V) ⁸	122515
Twist Lock Photocell (347V) for use with CR7P ⁸	122516
Twist Lock Photocell (480V) for use with CR7P ⁸	1225180
AirLink 5 Pin Twist Lock Controller ⁸	661409
AirLink 7 Pin Twist Lock Controller ⁸	661410
Shorting Cap for use with CR7P	149328

FUSING OPTIONS ¹¹	
Single Fusing (120V)	See Fusing Accessory Guide
Single Fusing (277V)	
Double Fusing (208V, 240V)	
Double Fusing (480V)	
Double Fusing (347V)	

SHIELDING OPTIONS	
Mirada Small	See Shielding Guide
Mirada Medium	
Mirada Large	
Zone Medium	
Zone Large	
Slice Medium	

1. Custom lumen and wattage packages available, consult factory. Values are within industry standard tolerances but not DLC listed.

2. Not available with 5W distribution

3. Consult Factory for availability.

4. Not available in HV.

5. Motion sensors are field configurable via an app that can be downloaded from your smartphone's native app store. See controls section for more details.

6. Control device or shorting cap must be ordered separately. See Accessory Ordering Information.

7. Accessories are shipped separately and field installed.

8. Factory installed CR7P option required. See Options.

9. "CLR" denotes finish. See Finish options.

10. Only available with ALSC/ALSCH control options.

11. Fusing must be located in hand hole of pole. See [Fusing Accessory Guide](#) for compatibility.



12. Only available in 9L, 12L, 18L and 24L Lumen Packages. Consult factory for lead time and availability.

Mirada Medium Outdoor LED Area Light

Type : _____

 Have questions? Call us at (800) 436-7800

ACCESSORIES

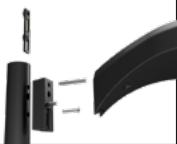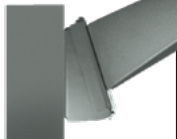MOUNTING ACCESSORIES		
Side Arm	Universal Mounting Bracket Mounts to ≥ 3" square or round (tapered/straight) poles with (2) mounting hole spaces between 3.5" to 5"	
	Part Number: BKA UMB CLR	
	Quick Mount Plate True one person installation to existing/new construction poles with hole spaces between 2.4 to 4.6"	
	Part Number: BKS PQM B3B5 XX CLR	
	15° Tilt Quick Mount Plate True one person installation to existing/new construction poles with hole spaces between 2.4 to 4.6"	
	Part Number: BKS PQ15 B3B5 XX CLR	
Tenon / Slipfitter	Adjustable Slipfitter Mounts onto a 2" (51mm) IP, 2.375" (60mm) O.D. tenon and provides 180° of tilt (max 45° above horizontal)	
	Part Number: BKA ASF CLR	
	Square Tenon Top Mounts onto a 2" (51mm) IP, 2.375" (60mm) O.D. tenon and allows for mounting up to 4 luminaires	
	Part Number: BKA XNM *	
	Square Internal Slipfitter Mounts inside 4" or 5" square pole and allows for mounting up to 4 luminaires	
	Part Number: BKA X_ISF * CLR	
Wall Mount/ Wood Pole	Wall Mount Bracket Mounts onto vertical wall surface (hardware/anchors not included)	
	Part Number: BKS XBO WM CLR	
	Wood Pole Bracket Mounts onto wooden poles (6" minimum OD, hardware/anchors not included)	
	Part Number: BKS XBO WP CLR	

SHIELDING, POLES & MISC. ACCESSORIES		
Shielding	Integral Louver Field Install Integral Louver provides maximum backlight control by shielding each individual row of LEDs Part Number: 690981	
	Integral Half Louver Field Install Integral Half Louver provides great backlight control without impacting front side distribution. Part Number: 743415	
	External Shield External shield blocks view of light source from anyside of luminaire, additional shielding configurations available Part Number: 783607BLK (3") / 776538BLK (6")	
Poles	Square Poles 14 - 39' steel and aluminum poles in 4", 5" and 6" sizes for retrofit and new construction Part Number: 4SQ/5SQ/6SQ	
	Round Poles 10 - 30' steel and aluminum poles in 4" and 5" sizes for retrofit and new construction Part Number: 4RP/5RP	
	Tapered Poles 20' - 39' steel and aluminum poles for retrofit and new construction Part Number: RTP	
Misc.	Bird Spikes 10' Linear Bird Spike Kit, 4' recommended per luminaire, includes silicone adhesive and application tool Part Number: 736795	

Replace CLR with paint finish description


Replace XX with SQ for square pole or RD for round pole (≥3" OD)

Replace * with S (Single), D180 (Double @180°), D90 (Double @90°), T90 (Triple), Q90 (Quad)

Replace _ with 4 (4" square pole) or 5 (5" square pole)

OPTICS ROTATION

Top View

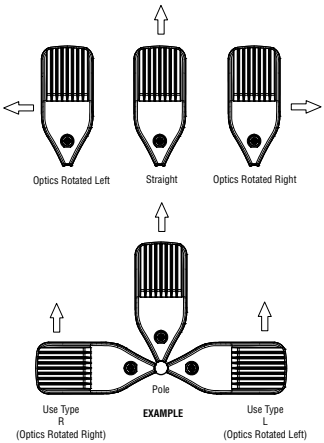

ACCESSORIES/OPTIONS

Integral Louver (IL) and House-Side Shield (IH)

Integral louver (IL) and half louver (IH) accessory shields available for improved backlight control without sacrificing street side performance. LSI's Integral Louver (IL) and Integral House-Side Shield (IH) options deliver backlight control that significantly reduces spill light behind the poles for applications with pole locations close to adjacent properties. The design maximizes forward reflected light while reducing glare, maintaining the optical distribution selected, and most importantly eliminating light trespass. Both options rotate

Luminaire Shown with Integral Louver (IL)



Luminaire Shown with IMSBTL Option



7 Pin Photoelectric Control

7-pin ANSI C136.41-2013 control receptacle option available for twist lock photocontrols or wireless control modules. Control accessories sold separately. Dimming leads from the receptacle will be connected to the driver dimming leads (Consult factory for alternate wiring).

Luminaire Shown with CR7P



Mirada Medium Outdoor LED Area Light

Type : _____

 Have questions? Call us at (800) 436-7800

PERFORMANCE

[Back to Quick Links](#)

DELIVERED LUMENS*												
Lumen Package	Distribution	CRI	3000K CCT			4000K CCT			5000K CCT			Wattage
			Delivered Lumens	Efficacy	BUG Rating	Delivered Lumens	Efficacy	BUG Rating	Delivered Lumens	Efficacy	BUG Rating	
9L	2	70	9853	159	B2-U0-G2	9853	159	B2-U0-G2	9853	159	B2-U0-G2	62
	3		9926	160	B2-U0-G2	9926	160	B2-U0-G2	9926	160	B2-U0-G2	
	4		9178	148	B2-U0-G3	9713	157	B2-U0-G3	9498	153	B2-U0-G3	
	5W		9504	153	B3-U0-G2	9504	153	B3-U0-G2	9504	153	B3-U0-G2	
	FT		9856	159	B2-U0-G3	9856	159	B2-U0-G3	9856	159	B2-U0-G3	
	FTA		9900	160	B2-U0-G2	9900	160	B2-U0-G2	9900	160	B2-U0-G2	
	AM		10019	162	B2-U0-G1	10019	162	B2-U0-G1	10019	162	B2-U0-G1	
	LC/RC		9008	145	B2-U0-G3	9533	154	B2-U0-G3	9321	150	B2-U0-G3	
12L	2	70	13135	155	B3-U0-G2	13135	155	B3-U0-G2	13135	155	B3-U0-G2	85
	3		13232	156	B2-U0-G2	13232	156	B2-U0-G2	13232	156	B2-U0-G2	
	4		12223	144	B2-U0-G3	12935	152	B2-U0-G4	12648	149	B2-U0-G4	
	5W		12669	149	B4-U0-G2	12669	149	B4-U0-G2	12669	149	B4-U0-G2	
	FT		13138	155	B2-U0-G3	13138	155	B2-U0-G3	13138	155	B2-U0-G3	
	FTA		13196	155	B2-U0-G2	13196	155	B2-U0-G2	13196	155	B2-U0-G2	
	AM		13355	157	B2-U0-G2	13355	157	B2-U0-G2	13355	157	B2-U0-G2	
	LC/RC		11996	141	B2-U0-G3	12695	149	B2-U0-G3	12414	146	B2-U0-G3	
18L	2	70	19318	143	B3-U0-G3	19318	143	B3-U0-G3	19318	143	B3-U0-G3	135
	3		19461	144	B3-U0-G3	19461	144	B3-U0-G3	19461	144	B3-U0-G3	
	4		18013	133	B2-U0-G4	19063	141	B3-U0-G5	18640	138	B3-U0-G5	
	5W		18633	138	B4-U0-G2	18633	138	B4-U0-G2	18633	138	B4-U0-G2	
	FT		19324	143	B3-U0-G3	19324	143	B3-U0-G3	19324	143	B3-U0-G3	
	FTA		19408	144	B3-U0-G3	19408	144	B3-U0-G3	19408	144	B3-U0-G3	
	AM		19641	145	B3-U0-G2	19641	145	B3-U0-G2	19641	145	B3-U0-G2	
	LC/RC		17679	131	B2-U0-G3	18710	139	B2-U0-G3	18295	136	B2-U0-G3	
24L	2	70	23361	145	B4-U0-G3	24506	152	B4-U0-G3	24414	152	B4-U0-G3	161
	3		23998	149	B3-U0-G3	25174	156	B3-U0-G3	25079	156	B3-U0-G3	
	4		24397	152	B3-U0-G5	25600	160	B3-U0-G5	25457	159	B3-U0-G5	
	5W		23788	148	B5-U0-G3	24953	155	B5-U0-G3	24859	154	B5-U0-G3	
	FT		24059	149	B3-U0-G3	25238	157	B3-U0-G3	25143	156	B3-U0-G3	
	FTA		23079	143	B3-U0-G3	24210	150	B4-U0-G3	24119	150	B4-U0-G3	
	AM		24051	149	B3-U0-G2	25229	157	B3-U0-G2	25134	156	B3-U0-G2	
	LC/RC		25884	162	B3-U0-G4	25884	162	B3-U0-G4	25310	158	B3-U0-G4	
30L	2	70	29464	138	B4-U0-G3	30908	145	B4-U0-G3	30791	145	B4-U0-G3	213
	3		30268	142	B3-U0-G4	31751	149	B3-U0-G4	31631	149	B3-U0-G4	
	4		30631	144	B3-U0-G5	32141	151	B3-U0-G5	31961	150	B3-U0-G5	
	5W		30002	141	B5-U0-G3	31472	148	B5-U0-G3	31353	147	B5-U0-G3	
	FT		30345	142	B4-U0-G4	31832	149	B4-U0-G4	31712	149	B4-U0-G4	
	FTA		29109	137	B4-U0-G4	30535	143	B4-U0-G4	30420	143	B4-U0-G4	
	AM		30334	142	B4-U0-G3	31820	149	B4-U0-G3	31700	149	B4-U0-G3	
	LC/RC		32498	153	B3-U0-G5	32498	153	B3-U0-G5	31777	149	B3-U0-G5	

*LEDs are frequently updated therefore values are nominal.

Mirada Medium Outdoor LED Area Light

Type : _____

 Have questions? Call us at (800) 436-7800

PERFORMANCE (CONT.)

DELIVERED LUMENS*												
Lumen Package	Distribution	CRI	3000K CCT			4000K CCT			5000K CCT			Wattage
			Delivered Lumens	Efficacy	BUG Rating	Delivered Lumens	Efficacy	BUG Rating	Delivered Lumens	Efficacy	BUG Rating	
36L	2	70	34123	134	B4-U0-G3	35795	140	B4-U0-G3	35660	140	B4-U0-G3	255
	3		35053	137	B4-U0-G4	36771	144	B4-U0-G4	36632	144	B4-U0-G4	
	4		35402	139	B3-U0-G5	37148	146	B4-U0-G5	36940	145	B4-U0-G5	
	5W		34745	136	B5-U0-G4	36448	143	B5-U0-G4	36311	142	B5-U0-G4	
	FT		35142	138	B4-U0-G4	36864	145	B4-U0-G4	36725	144	B4-U0-G4	
	FTA		33711	132	B4-U0-G4	35363	139	B4-U0-G4	35230	138	B4-U0-G4	
	AM		35130	138	B4-U0-G3	36851	145	B4-U0-G3	36712	144	B4-U0-G3	
	LC/RC		37561	147	B3-U0-G5	37561	147	B3-U0-G5	36727	144	B3-U0-G5	
42L	2	70	39966	127	B5-U0-G4	41925	134	B5-U0-G4	41767	133	B5-U0-G4	314
	3		41056	131	B4-U0-G5	43068	137	B4-U0-G5	42905	137	B4-U0-G5	
	4		41453	132	B4-U0-G5	43497	138	B4-U0-G5	43254	138	B4-U0-G5	
	5W		40696	130	B5-U0-G4	42690	136	B5-U0-G4	42529	135	B5-U0-G4	
	FT		41161	131	B4-U0-G4	43178	138	B4-U0-G4	43015	137	B4-U0-G4	
	FTA		39484	126	B4-U0-G4	41419	132	B5-U0-G4	41263	131	B5-U0-G4	
	AM		41146	131	B4-U0-G3	43162	137	B4-U0-G3	43000	137	B4-U0-G3	
	LC/RC		43980	140	B3-U0-G5	43980	140	B3-U0-G5	43004	137	B3-U0-G5	
48L	2	70	44390	121	B5-U0-G4	46565	127	B5-U0-G4	46389	126	B5-U0-G4	367
	3		45325	124	B4-U0-G5	47547	130	B4-U0-G5	47367	129	B4-U0-G5	
	4		46006	126	B4-U0-G5	48275	132	B4-U0-G5	48005	131	B4-U0-G5	
	5W		45002	123	B5-U0-G4	47435	129	B5-U0-G4	47302	129	B5-U0-G4	
	FT		44799	122	B4-U0-G5	46994	128	B4-U0-G5	46817	128	B4-U0-G5	
	FTA		44590	121	B5-U0-G4	46775	127	B5-U0-G4	46599	128	B5-U0-G4	
	AM		46310	126	B4-U0-G3	48579	132	B4-U0-G3	48396	132	B4-U0-G3	
	LC/RC		48811	133	B4-U0-G5	48811	133	B4-U0-G5	47728	130	B4-U0-G5	
55L	2	70	49583	114	B5-U0-G4	52012	119	B5-U0-G4	51816	119	B5-U0-G4	436
	3		50934	117	B4-U0-G5	53430	123	B4-U0-G5	53229	122	B4-U0-G5	
	4		51635	119	B4-U0-G5	54181	125	B4-U0-G5	53878	124	B4-U0-G5	
	5W		50487	116	B5-U0-G4	52961	121	B5-U0-G4	52761	121	B5-U0-G4	
	FT		51064	117	B4-U0-G5	53566	123	B4-U0-G5	53364	122	B4-U0-G5	
	FTA		48984	112	B5-U0-G4	51384	118	B5-U0-G4	51191	117	B5-U0-G4	
	AM		51045	117	B4-U0-G3	53546	123	B4-U0-G3	53344	122	B4-U0-G3	
	LC/RC		54113	124	B4-U0-G5	54113	124	B4-U0-G5	52912	121	B4-U0-G5	

*LEDs are frequently updated therefore values are nominal.

Mirada Medium Outdoor LED Area Light

Type : _____

 Have questions? Call us at (800) 436-7800

PERFORMANCE (CONT.)

ELECTRICAL DATA (AMPS)*						
Lumens	120V	208V	240V	277V	347V	480V
9L	0.52	0.30	0.26	0.22	0.18	0.13
12L	0.71	0.41	0.35	0.31	0.24	0.18
18L	1.13	0.65	0.56	0.49	0.39	0.28
24L	1.33	0.77	0.67	0.58	0.46	0.33
30L	1.78	1.02	0.89	0.77	0.61	0.44
36L	2.12	1.22	1.06	0.92	0.73	0.53
42L	2.62	1.51	1.31	1.13	0.90	0.65
48L	3.05	1.76	1.53	1.32	1.05	0.76
55L	3.65	2.11	1.83	1.58	1.26	0.91

RECOMMENDED LUMEN MAINTENANCE¹ (0-25°C)					
Ambient	Initial²	25h²	50hr²	75hr²	100hr²
9L - 18L	100%	97%	93%	90%	86%
24L - 48L	100%	95%	89%	84%	79%
55L	100%	91%	82%	74%	67%

RECOMMENDED LUMEN MAINTENANCE¹ (40°C)					
Ambient	Initial²	25h²	50hr²	75hr²	100hr²
9L - 18L	100%	97%	92%	88%	84%
24L - 48L	100%	94%	87%	80%	74%

RECOMMENDED LUMEN MAINTENANCE¹ (50°C)					
Ambient	Initial²	25h²	50hr²	75hr²	100hr²
9L - 18L C	100%	96%	91%	87%	83%

*Electrical data at 25°C (77°F). Actual wattage may differ by +/-10%

1. Lumen maintenance values at 25C are calculated per TM-21 based on LM-80 data and in-situ testing.
2. In accordance with IESNA TM-21-11, Projected Values represent interpolated value based on time durations that are within six times the IESNA LM-80-08 total test duration for the device under testing.
3. In accordance with IESNA TM-21-11, Calculated Values represent time durations that exceed six times the IESNA LM-80-08 total test duration for the device under testing.

DELIVERED LUMENS*					
Lumen Package	Distribution	Phosphor Converted Amber (Peak 610nm)			Wattage
		Delivered Lumens	Efficacy	BUG Rating	
9L	2	5848	80	B2-U0-G2	74
	3	6018	82	B1-U0-G2	
	5W	5471	74	B3-U0-G1	
	FT	5801	79	B1-U0-G2	
	FTA	5924	81	B1-U0-G1	
	AM	5995	81	B1-U0-G1	
12L	2	7530	74	B2-U0-G2	102
	3	7749	76	B1-U0-G2	
	5W	7045	69	B3-U0-G2	
	FT	7470	73	B2-U0-G2	
	FTA	7628	75	B2-U0-G2	
	AM	7720	76	B1-U0-G1	
18L	2	9311	69	B2-U0-G2	135
	3	9582	71	B2-U0-G2	
	5W	8712	65	B3-U0-G2	
	FT	9237	68	B2-U0-G2	
	FTA	9433	70	B2-U0-G2	
	AM	9546	71	B2-U0-G1	
24L	2	10955	63	B2-U0-G2	175
	3	11273	64	B2-U0-G2	
	5W	10249	59	B3-U0-G2	
	FT	10867	62	B2-U0-G2	
	FTA	11097	63	B2-U0-G2	
	AM	11230	64	B2-U0-G1	

ELECTRICAL DATA - PHOSPHOR CONVERTED AMBER (AMPS)*						
Lumens	120V	208V	240V	277V	347V	480V
9L	0.62	0.36	0.31	0.27	0.21	0.15
12L	0.85	0.50	0.43	0.38	0.30	0.22
18L	1.13	0.65	0.56	0.49	0.39	0.28
24L	1.47	0.85	0.73	0.64	0.51	0.37

*LEDs are frequently updated therefore values are nominal.

Mirada Medium Outdoor LED Area Light

Type : _____

 Have questions? Call us at (800) 436-7800

PHOTOMETRICS

[Back to Quick Links](#)

Luminaire photometry has been conducted by a NVLAP accredited testing laboratory in accordance with IESNA LM-79-08. As specified by IESNA LM-79-08 the entire luminaire is tested as the source resulting in a luminaire efficiency of 100%.


See the individual product page on <https://www.isicorp.com/> for detailed photometric data.

MRM-LED-30L-SIL-2-40-70CRI

Luminaire Data	
Type 2 Distribution	
Description	4000 Kelvin, 70 CRI
Delivered Lumens	32,416
Watts	232
Efficacy	140
IES Type	Type II - Short
BUG Rating	B4-U0-G3


Zonal Lumen Summary		
Zone	Lumens	% Luminaire
Low (0-30°)	4796	15%
Medium (30-60°)	19811	61%
High (60-80°)	7474	23%
Very High (80-90°)	335	1%
Uplight (90-180°)	0	0%
Total Flux	32416	100%

ISO Footcandle

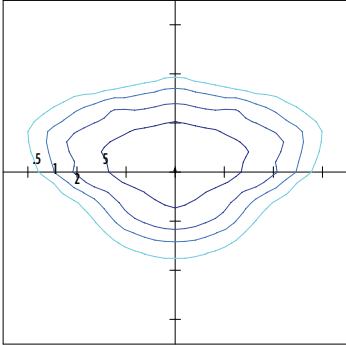

25' Mounting Height / 25' Grid Spacing
■ 5 FC ■ 2 FC ■ 1 FC ■ 0.5 FC

Polar Curve

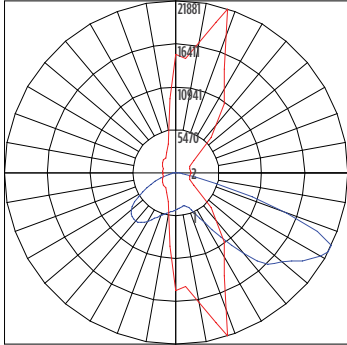


■ Vertical Plane ■ Horizontal Cone

MRM-LED-30L-SIL-3-40-70CRI

Luminaire Data	
Type 3 Distribution	
Description	4000 Kelvin, 70 CRI
Delivered Lumens	32,656
Watts	232
Efficacy	141
IES Type	Type III - Short
BUG Rating	B3-U0-G4


Zonal Lumen Summary		
Zone	Lumens	% Luminaire
Low (0-30°)	3385	10%
Medium (30-60°)	16250	50%
High (60-80°)	12430	38%
Very High (80-90°)	591	2%
Uplight (90-180°)	0	0%
Total Flux	32656	100%

ISO Footcandle

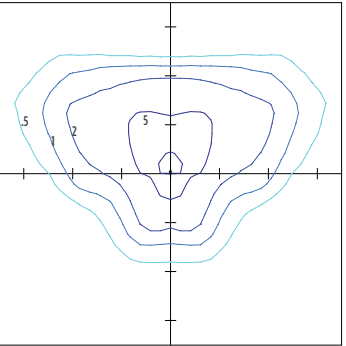

25' Mounting Height / 25' Grid Spacing
■ 5 FC ■ 2 FC ■ 1 FC ■ 0.5 FC

Polar Curve

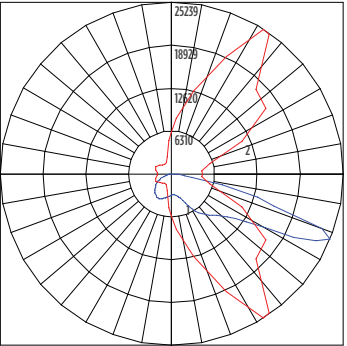


■ Vertical Plane ■ Horizontal Cone

MRM-LED-30L-SIL-FT-40-70CRI

Luminaire Data	
Type FT Distribution	
Description	4000 Kelvin, 70 CRI
Delivered Lumens	32,424
Watts	232
Efficacy	140
IES Type	Type IV - Short
BUG Rating	B3-U0-G4


Zonal Lumen Summary		
Zone	Lumens	% Luminaire
Low (0-30°)	3952	12%
Medium (30-60°)	15505	48%
High (60-80°)	12279	38%
Very High (80-90°)	688	2%
Uplight (90-180°)	0	0%
Total Flux	32424	100%

ISO Footcandle

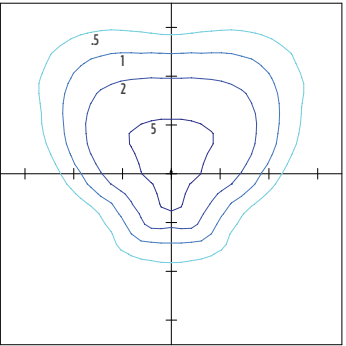

25' Mounting Height / 25' Grid Spacing
■ 5 FC ■ 2 FC ■ 1 FC ■ 0.5 FC

Polar Curve

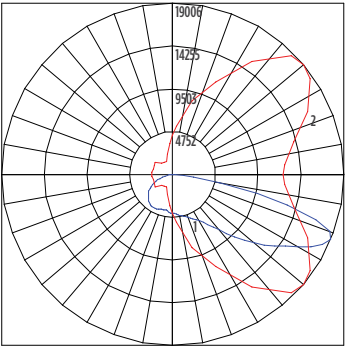

■ Vertical Plane ■ Horizontal Cone

Mirada Medium Outdoor LED Area Light

Type : _____



 Have questions? Call us at (800) 436-7800

PHOTOMETRICS (CONT)

MRM-LED-30L-SIL-4-40-70CRI

Luminaire Data	
Type 4 Distribution	
Description	4000 Kelvin, 70 CRI
Delivered Lumens	32,141
Watts	213
Efficacy	151
IES Type	Type IV - Very Short
BUG Rating	B3-U0-G5



Zonal Lumen Summary		
Zone	Lumens	% Luminaire
Low (0-30°)	3119	10%
Medium (30-60°)	13569	42%
High (60-80°)	13649	42%
Very High (80-90°)	1804	6%
Uplight (90-180°)	0	0%
Total Flux	32141	100%

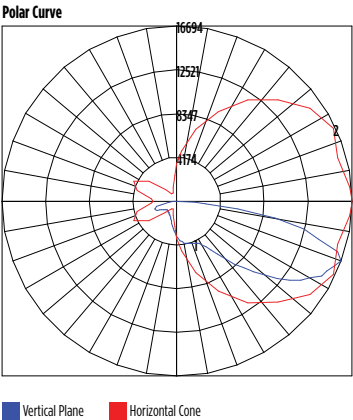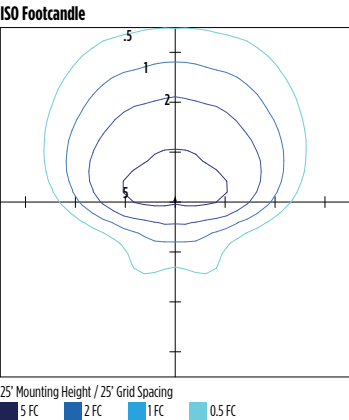

MRM-LED-30L-SIL-5W-40-70CRI

Luminaire Data	
Type 5W Distribution	
Description	4000 Kelvin, 70 CRI
Delivered Lumens	31,267
Watts	232
Efficacy	135
IES Type	Type VS - Short
BUG Rating	B5-U0-G3



Zonal Lumen Summary		
Zone	Lumens	% Luminaire
Low (0-30°)	3138	10%
Medium (30-60°)	13193	42%
High (60-80°)	14641	47%
Very High (80-90°)	296	1%
Uplight (90-180°)	0	0%
Total Flux	31267	100%

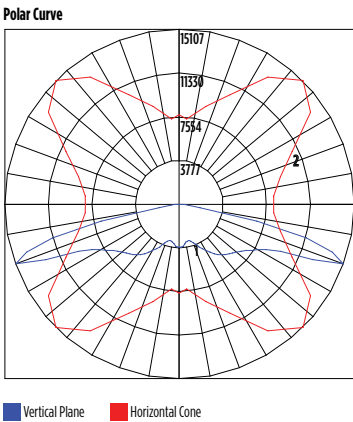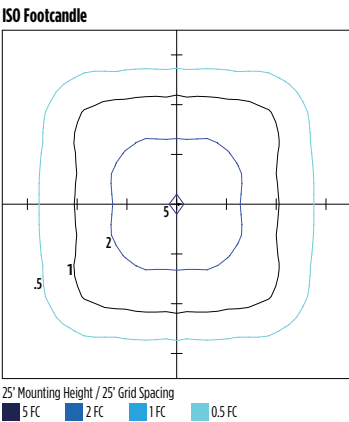

MRM-LED-30L-SIL-FTA-40-70CRI

Luminaire Data	
Type FTA Distribution	
Description	4000 Kelvin, 70 CRI
Delivered Lumens	32,566
Watts	232
Efficacy	140
IES Type	Type VS - Short
BUG Rating	B4-U0-G3

Zonal Lumen Summary		
Zone	Lumens	% Luminaire
Low (0-30°)	6986	21%
Medium (30-60°)	19172	59%
High (60-80°)	5875	18%
Very High (80-90°)	534	2%
Uplight (90-180°)	0	0%
Total Flux	32566	100%

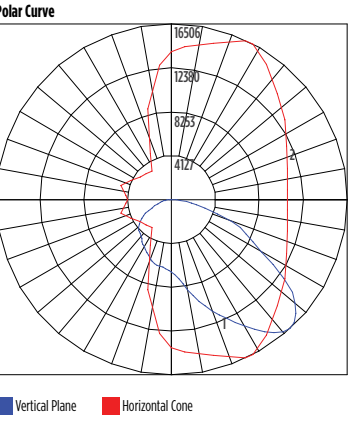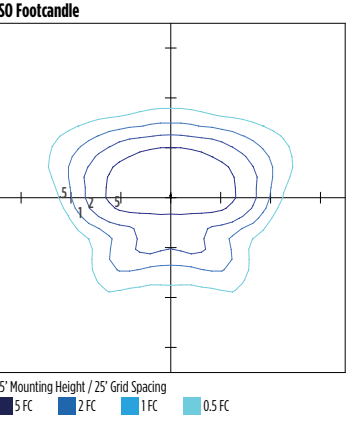

Mirada Medium Outdoor LED Area Light

Type : _____

 Have questions? Call us at (800) 436-7800

PHOTOMETRICS (CONT)


[Back to Quick Links](#)

MRM-LED-30L-SIL-AM-40-70CRI

Luminaire Data	
Type AM Distribution	
Description	4000 Kelvin, 70 CRI
Delivered Lumens	32,960
Watts	232
Efficacy	142
IES Type	Type III - Very Short
BUG Rating	B3-U0-G3


Zonal Lumen Summary		
Zone	Lumens	% Luminaire
Low (0-30°)	6363	19%
Medium (30-60°)	22026	67%
High (60-80°)	4192	13%
Very High (80-90°)	379	1%
Uplight (90-180°)	0	0%
Total Flux	32960	100%

ISO Footcandle

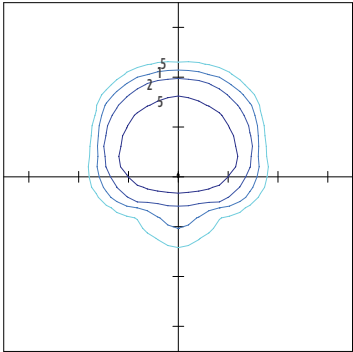

25' Mounting Height / 25' Grid Spacing
■ 5 FC ■ 2 FC ■ 1 FC ■ 0.5 FC

Polar Curve

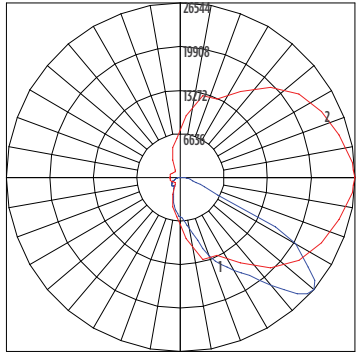


■ Vertical Plane ■ Horizontal Cone

MRM-LED-30L-SIL-LC-40-70CRI

Luminaire Data	
Left Corner Distribution	
Description	4000 Kelvin, 70 CRI
Delivered Lumens	32,498
Watts	213
Efficacy	153
IES Type	N/A
BUG Rating	B3-U0-G5


Zonal Lumen Summary		
Zone	Lumens	% Luminaire
Low (0-30°)	5083	16%
Medium (30-60°)	14808	46%
High (60-80°)	11603	36%
Very High (80-90°)	1005	3%
Uplight (90-180°)	0	0%
Total Flux	32498	100%

ISO Footcandle

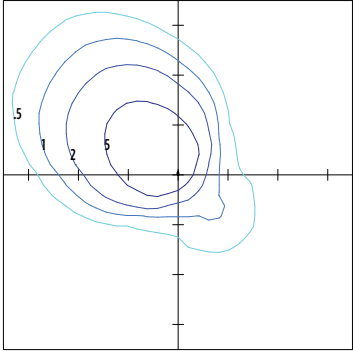

25' Mounting Height / 25' Grid Spacing
■ 5 FC ■ 2 FC ■ 1 FC ■ 0.5 FC

Polar Curve

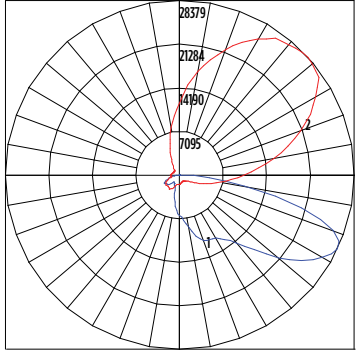


■ Vertical Plane ■ Horizontal Cone

MRM-LED-30L-SIL-RC-40-70CRI

Luminaire Data	
Right Corner Distribution	
Description	4000 Kelvin, 70 CRI
Delivered Lumens	32,498
Watts	213
Efficacy	153
IES Type	N/A
BUG Rating	B3-U0-G5


Zonal Lumen Summary		
Zone	Lumens	% Luminaire
Low (0-30°)	5083	16%
Medium (30-60°)	14808	46%
High (60-80°)	11603	36%
Very High (80-90°)	1005	3%
Uplight (90-180°)	0	0%
Total Flux	32498	100%

ISO Footcandle

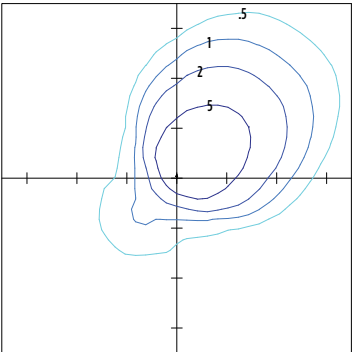

25' Mounting Height / 25' Grid Spacing
■ 5 FC ■ 2 FC ■ 1 FC ■ 0.5 FC

Polar Curve

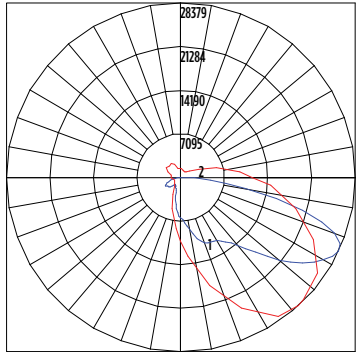


■ Vertical Plane ■ Horizontal Cone

Mirada Medium Outdoor LED Area Light

Type : _____

 Have questions? Call us at (800) 436-7800

PRODUCT DIMENSIONS

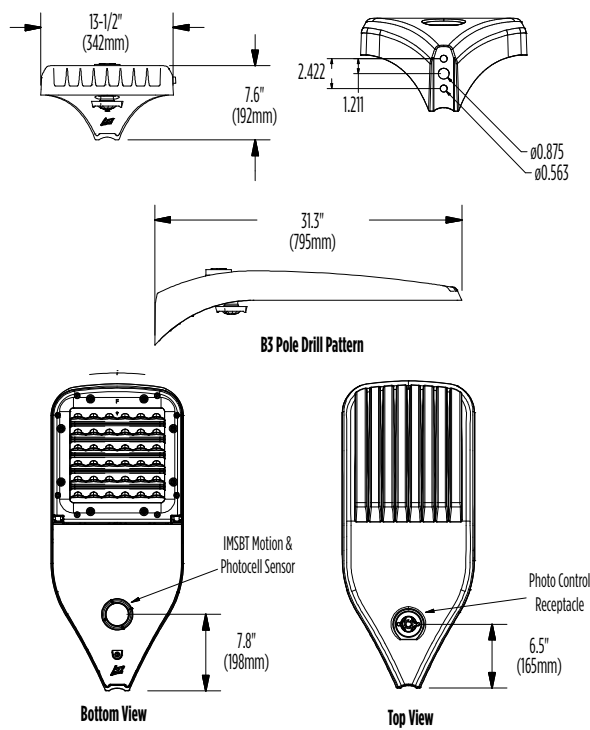

Luminaire EPA Chart					
Tilt Degree		0°	15°	30°	45°
	Single	0.5	1.0	1.5	1.9
	D180°	1.0	1.5	1.5	1.9
	D90°	0.8	1.8	1.9	2.3
	T90°	1.0	4.0	2.5	2.8
	TN120°	1.0	2.9	3.3	3.9
	Q90°	1.0	4.0	2.5	2.8

Mirada Medium Outdoor LED Area Light

Type : _____

 Have questions? Call us at (800) 436-7800

CONTROLS

Integral Bluetooth™ Motion and Photocell Sensor (IMSBTxL)

Slim low profile sensor provides multi-level control based on motion and/or daylight. Sensor controls 0-10 VDC LED drivers and is IP66 rated for cold and wet locations (-40°F to 167°F). Two unique PIR lenses are available and used based on fixture mounting height. All control parameters are adjustable via an iOS or Android App capable of storing and transmitting sensor profiles.

[Click here to learn more details about IMSBT](#)



LEVITON App



Apple



Android

AirLink Blue (ALBCSx)

Wireless Bluetooth Mesh Outdoor Lighting Control System that provides energy savings, code compliance and enhanced safety/security for parking lots and parking garages. Three key components; Bluetooth wireless radio/sensor controller, Time Keeper and an iOS App. Capable of grouping multiple fixtures and sensors as well as scheduling time-based events by zone. Radio/Sensor Controller is factory integrated into Area/ Site, Wall Mounted, Parking Garage and Canopy luminaires.

[Click here to learn more details about AirLink Blue](#)



AirLink Blue App



Apple

Sensor Sequence of Operations

Standard Programming	On Event	Off Event	On Light Level	Dim Light Level	Daylight Harvesting	Delay To Off	Sensitivity
OMSBTxL/IMSBTxL	Motion	No Motion	100%	N/A	On; Auto Calibration	20 minutes	High
OMS	Motion	No Motion	N/A	N/A	N/A	30 seconds	Auto

Operation	Description
On Event	Trigger that activates lights to turn on; either automatic via motion detected or manually activated via push of button.
Off Event	Trigger that activates lights to turn off; either automatic via no motion detected or manually activated via push of button.
On Light Level	The light level that the fixtures will turn on to when ON EVENT occurs.
Dim Light Level	The light level that the fixtures will dim down to when no motion is detected.
Delay to Dim	The amount of time after which no motion is detected that the fixtures will be triggered to dim down. This sequence is optional, and sensor can be programmed to only trigger the fixture to turn off by entering 100% in this field.
Delay to Off	The amount of time after which no motion is detected that the fixtures will be triggered to turn off. If delay to dim is part of the programmed functionality, this is the amount of time after which no motion is detected after the fixture have already dimmed down.
Sensitivity	The sensitivity can be set to high, medium, low, or auto where applicable. High will detect smaller, simple motions. Low will only detect larger more complex motions. Auto temperature calibration adjusts the PIR sensitivity as ambient temperature rises to increase detection of heat movement through the field of view.





Slim Wall Pack (WPSLL)

Large LED Slim Wall Pack



OVERVIEW

Lumen Package (lm)	4,000 - 8,000
Wattage Range (W)	40 - 72
Efficacy Range (LPW)	106 - 127
Weight lbs (kg)	8.9 (4.0)

QUICK LINKS

FEATURES & SPECIFICATIONS

Construction

- Rigid Precision Die cast-aluminum housing for durability and consistency.
- Vertical fins serve as a heat sink and resist accumulation of dust and debris.
- Thermal stacking heat removal technology extracts heat from within the housing moving it away from LEDs and integral components.
- Luminaire hinges open from the bottom to prevent leakage.
- Luminaire is proudly manufactured and tested in the U.S.
- Fixtures are finished with polyester powder coat finishing process to withstand extreme weather changes without cracking or peeling.

Optical System

- High-performance LEDs behind clear tempered glass for maximum light output and durability.
- Available in 5000K, 4500K, 4000K, and 3000K color temperatures per ANSI C78.377
- Minimum CRI of 80 for 4000K, 4500K, 5000K. Minimum CRI of 70 for 3000K.
- Zero uplight.

Electrical

- High-performance driver features overvoltage, under voltage, short-circuit and over temperature protection.
- 0-10 volt dimming (10% - 100%) standard.
- Standard Universal Voltage (120-277 Vac) Input 50/60 Hz
- L70 Calculated Life: >100k Hours
- Total harmonic distortion: <20%
- Power factor: >.85
- Input power stays constant over life.
- Driver Off-State Power is 0 watts.
- LEDs with integrated circuit board mounted directly to the housing to maximize heat dissipation and promote long life.
- Components are fully encased in potting material for moisture resistance. Driver complies with FCC standards. Driver and key electronic components can easily be accessed.
- Minimum 2.5kV surge rating
- Operating temperature: -40°C to +50°C (-40°F to +122°F).

Controls

- Optional 120-277V electronic button Photocontrol.
- Apertures for field or factory installed photocontrol.

Installation

- Surface mounts direct to J-box or wall.
- Features a bubble level and removable hinged face frame for ease of installation..

Warranty

- LSI luminaires carry a 5-year limited warranty. Refer to <https://www.lsicorp.com/resources/terms-conditions/warranty/> for more information.
- 1 Year warranty on optional Button Photocell.

Listings

- Listed to UL 1598 and UL 8750.
- Meets Buy American Act requirements.
- DarkSky Approved with 3000K color temperature selection.
- CSA Listed.
- RoHS Compliant.
- State of California Title 24.
- Suitable For Wet Locations.
- DesignLights Consortium® (DLC) Premium qualified product. Not all versions of this product may be DLC Premium qualified. Please check the DLC Qualified Products List at www.designlights.org/QPL to confirm which versions are qualified.



ORDERING GUIDE

TYPICAL ORDER EXAMPLE: WPSLL LED 6L UNV DIM 30 PCIUNV BZA

Prefix	Lumen Package	Voltage	Color Temperature	Controls	Options	Finish
WPSLL LED - Large Slim Wall Pack	4L - 4,000 lms (40w) 6L - 6,000 lms (60w) 8L - 8,000 lms (72w)	UNV DIM - Universal (120V-277V) HV DIM - 347-480V Universal Voltage	50 - 5000K 45 - 4500K 40 - 4000K 30 - 5000K (Dark Sky Approved)	PCIUNV - 120-227V Photocontrol	CWBB - Emergency Back-up ¹	BZA - Bronze BLK - Black SLV - Silver WHT - White

 Need more information?
Click here for our glossary

Have additional questions?
Call us at (800) 436-7800 

PERFORMANCE

Delivered Lumens							
Lumen Package	4000K - 80CRI		4500K - 80CRI		5000K - 80CRI		Wattage
	Delivered Lumens	Efficacy	Delivered Lumens	Efficacy	Delivered Lumens	Efficacy	
4L	4640	116	4872	127	4424	111	40
6L	6655	112	6987	123	6346	106	60
8L	7915	110	8387	121	7617	106	72

Delivered Lumens			
Lumen Package	3000K - 70CRI		Wattage
	Delivered Lumens	Efficacy	
4L	4147	111	40
6L	6513	112	60
8L	8060	106	80

Electrical Data - Current Draw AMPS						
Lumen Package	120V	208V	240V	277V	347V	480V
4L	0.33	0.19	0.17	0.14	0.12	0.08
6L	0.50	0.29	0.25	0.22	0.17	0.13
8L	0.60	0.35	0.30	0.26	0.21	0.15

ACCESSORIES / OPTIONS

Battery Backup

Emergency battery system provides 90-minutes of constant power to the LED system, ensuring code compliance. A test switch/indicator button is installed on the side of the back housing for ease of maintenance. Fixtures specified with CWBB options deliver ~1,200 lumens during emergency mode.

Luminaire Shown with battery backup test switch/indicator button



¹ 120-277V Only. Not available with 8L and 3000K selection.

PHOTOMETRICS



Luminaire photometry has been conducted by a NVLAP accredited testing laboratory in accordance with IESNA LM-79-08. As specified by IESNA LM-79-08 the entire luminaire is tested as the source resulting in a luminaire efficiency of 100%.

See the individual product page on <https://www.lsicorp.com/> for detailed photometric data.

WPSLL-6L-40

Luminaire Data		
Wide Distribution		
Description	4000 Kelvin, 80 CRI	
Delivered Lumens	7,988	
Watts	72	
Efficacy	111	
IES Type	Type III - Very Short	
BUG Rating	B2-U0-G1	

Zonal Lumen Summary		
Zone	Lumens	% Luminaire
Low (0-30°)	2165.0	27.1%
Medium (30-60°)	4371.3	54.8%
High (60-80°)	1411.8	17.6%
Very High (80-90°)	40.0	0.5%
Uplight (90-180°)	0.0	0.0%
Total Flux	7987.6	100%

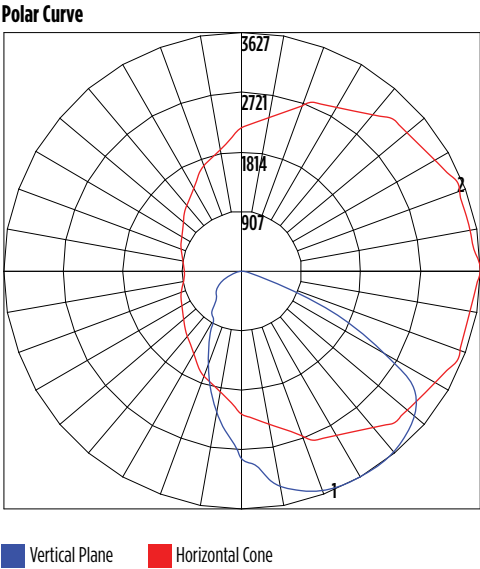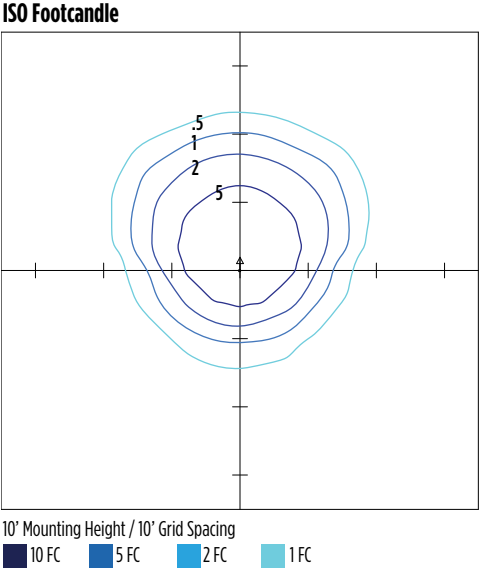

PRODUCT DIMENSIONS

